
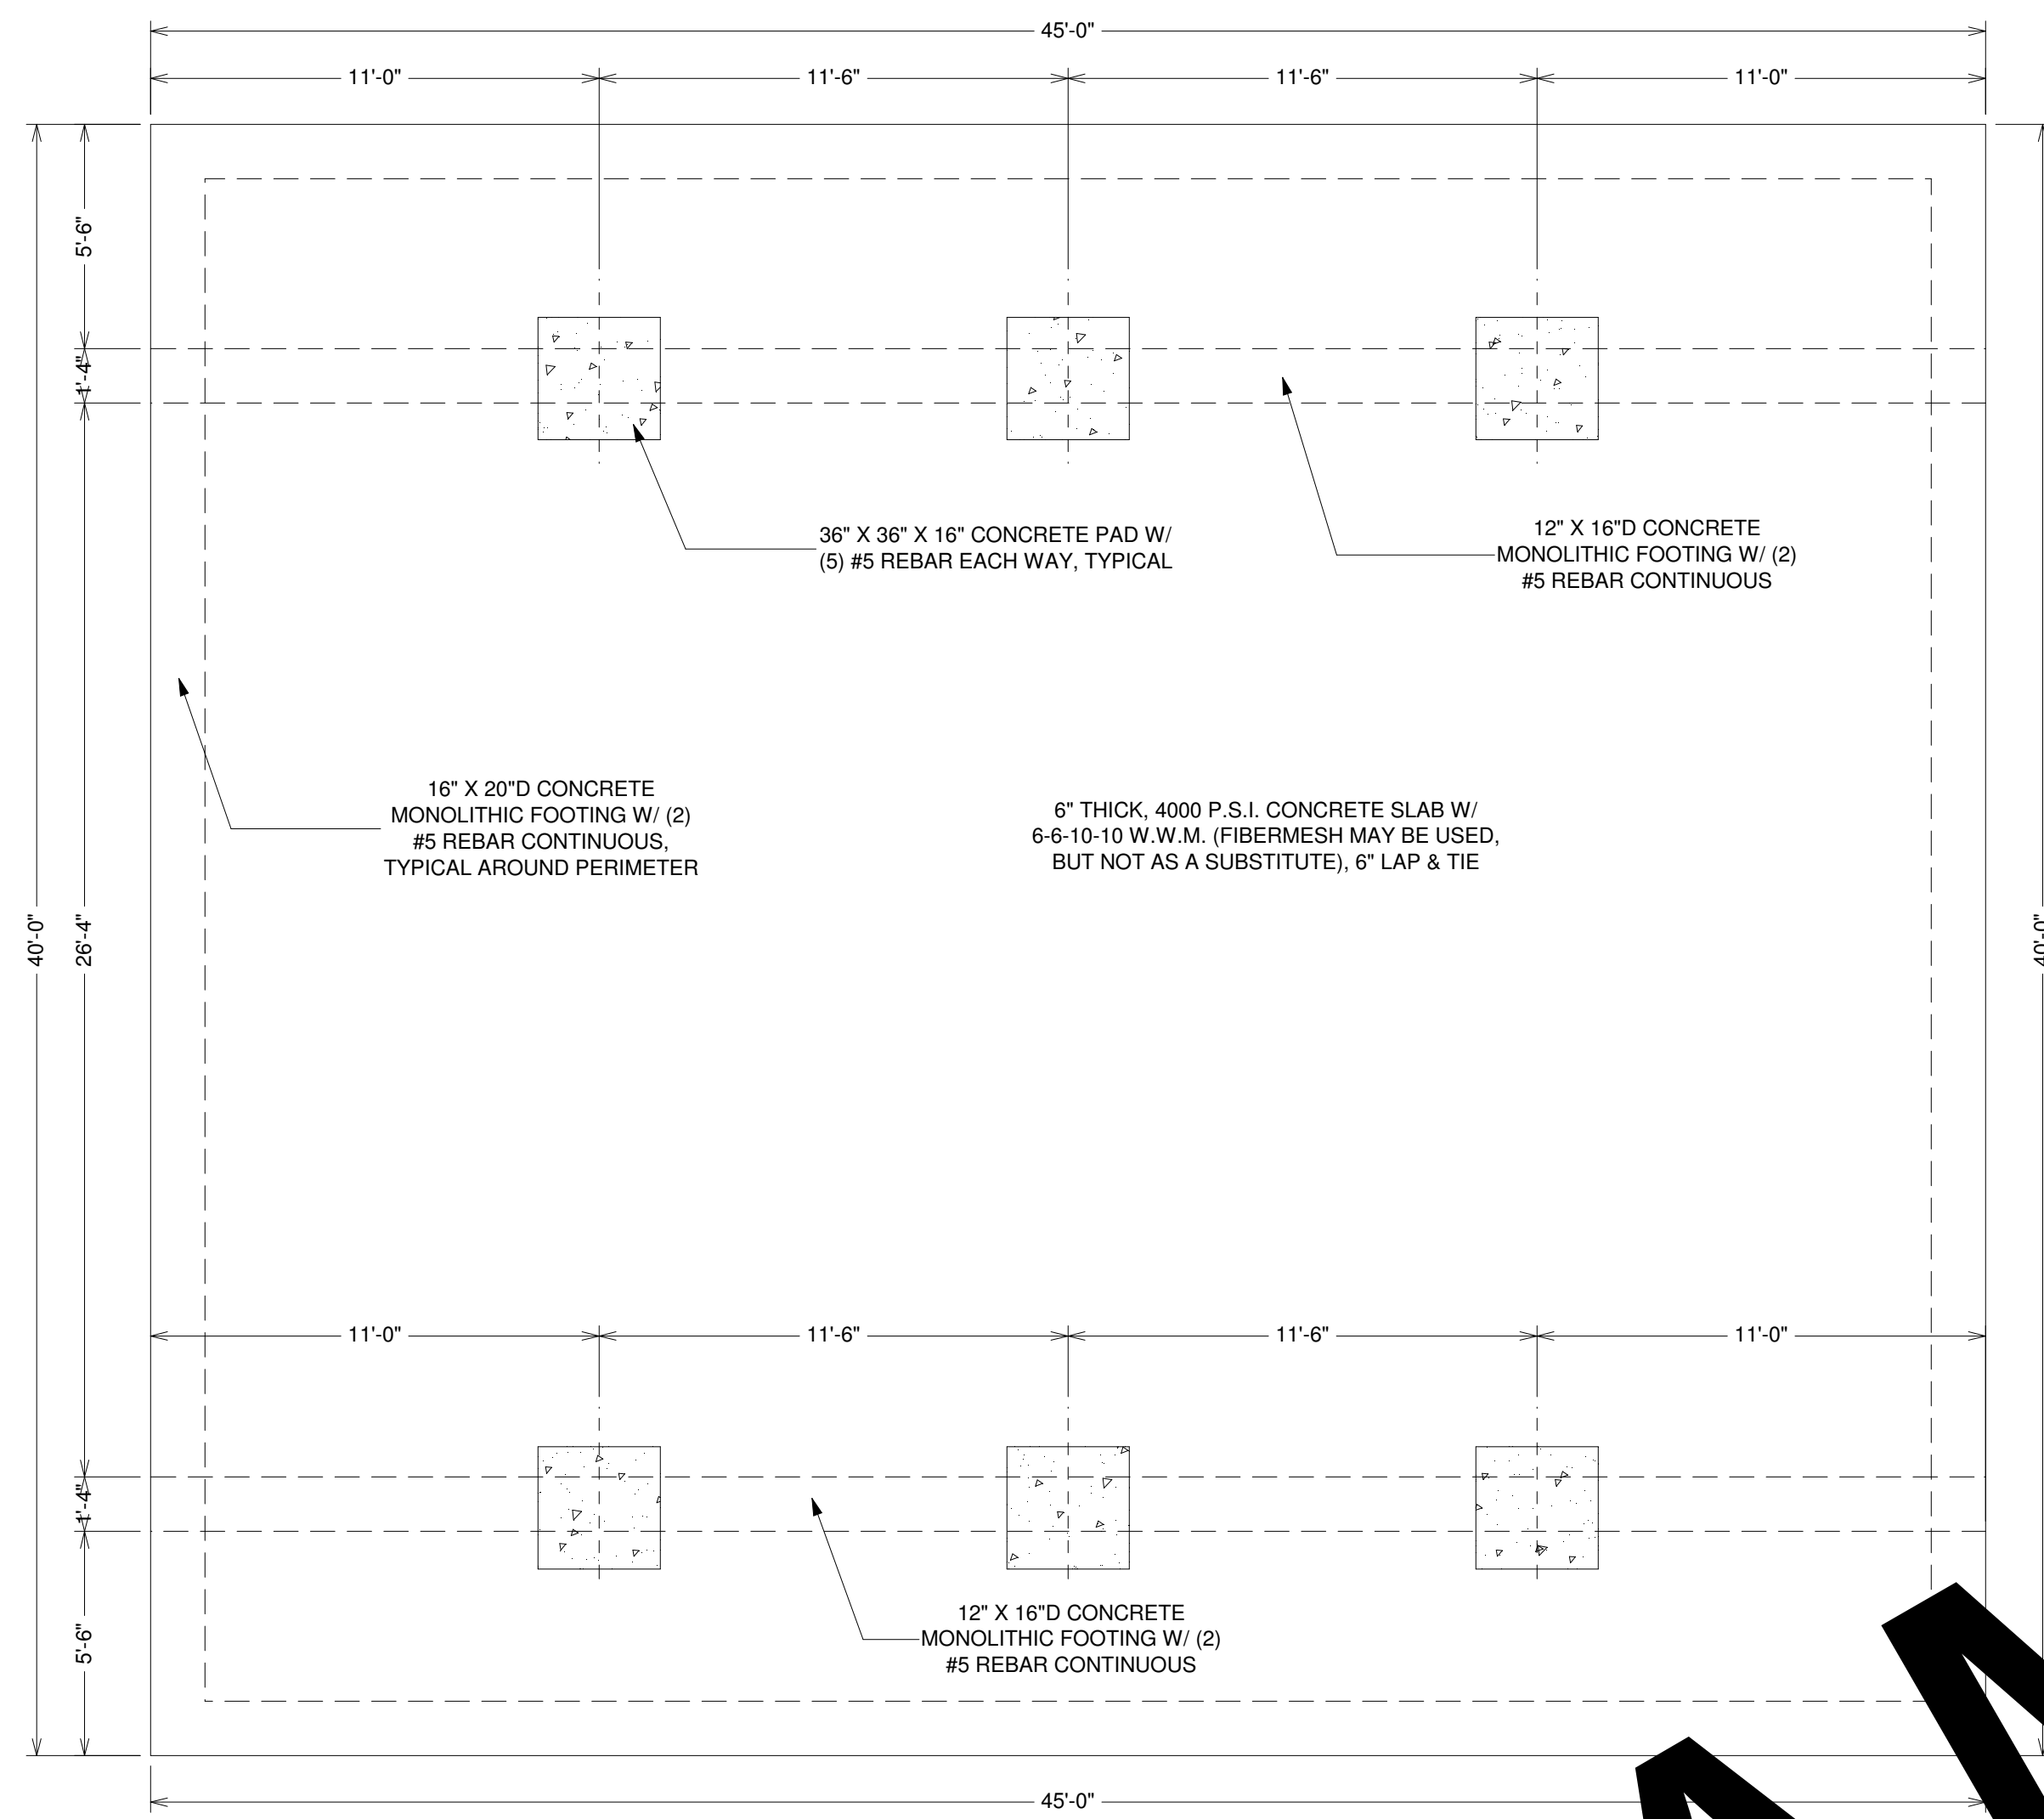



THIS DESIGN IS THE INTELLECTUAL PROPERTY OF DREAMCATCHER BUILDING DESIGNS. IT IS NOT TO BE REPRODUCED OR REUSED WITHOUT THE EXPRESS CONSENT OF DREAMCATCHER BUILDING DESIGNS.

SAMPLE RV GARAGE  
BRADENTON, FLORIDA

Dreamcatcher  
Building Designs  
(941) 462-0110  
www.DreamcatcherBuildingDesigns.com

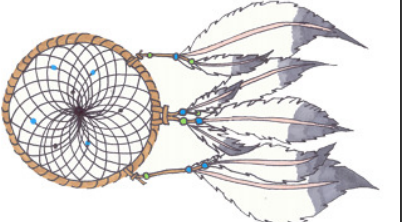

FOUNDATION PLAN  
SCALE: 1/4" = 1'-0"

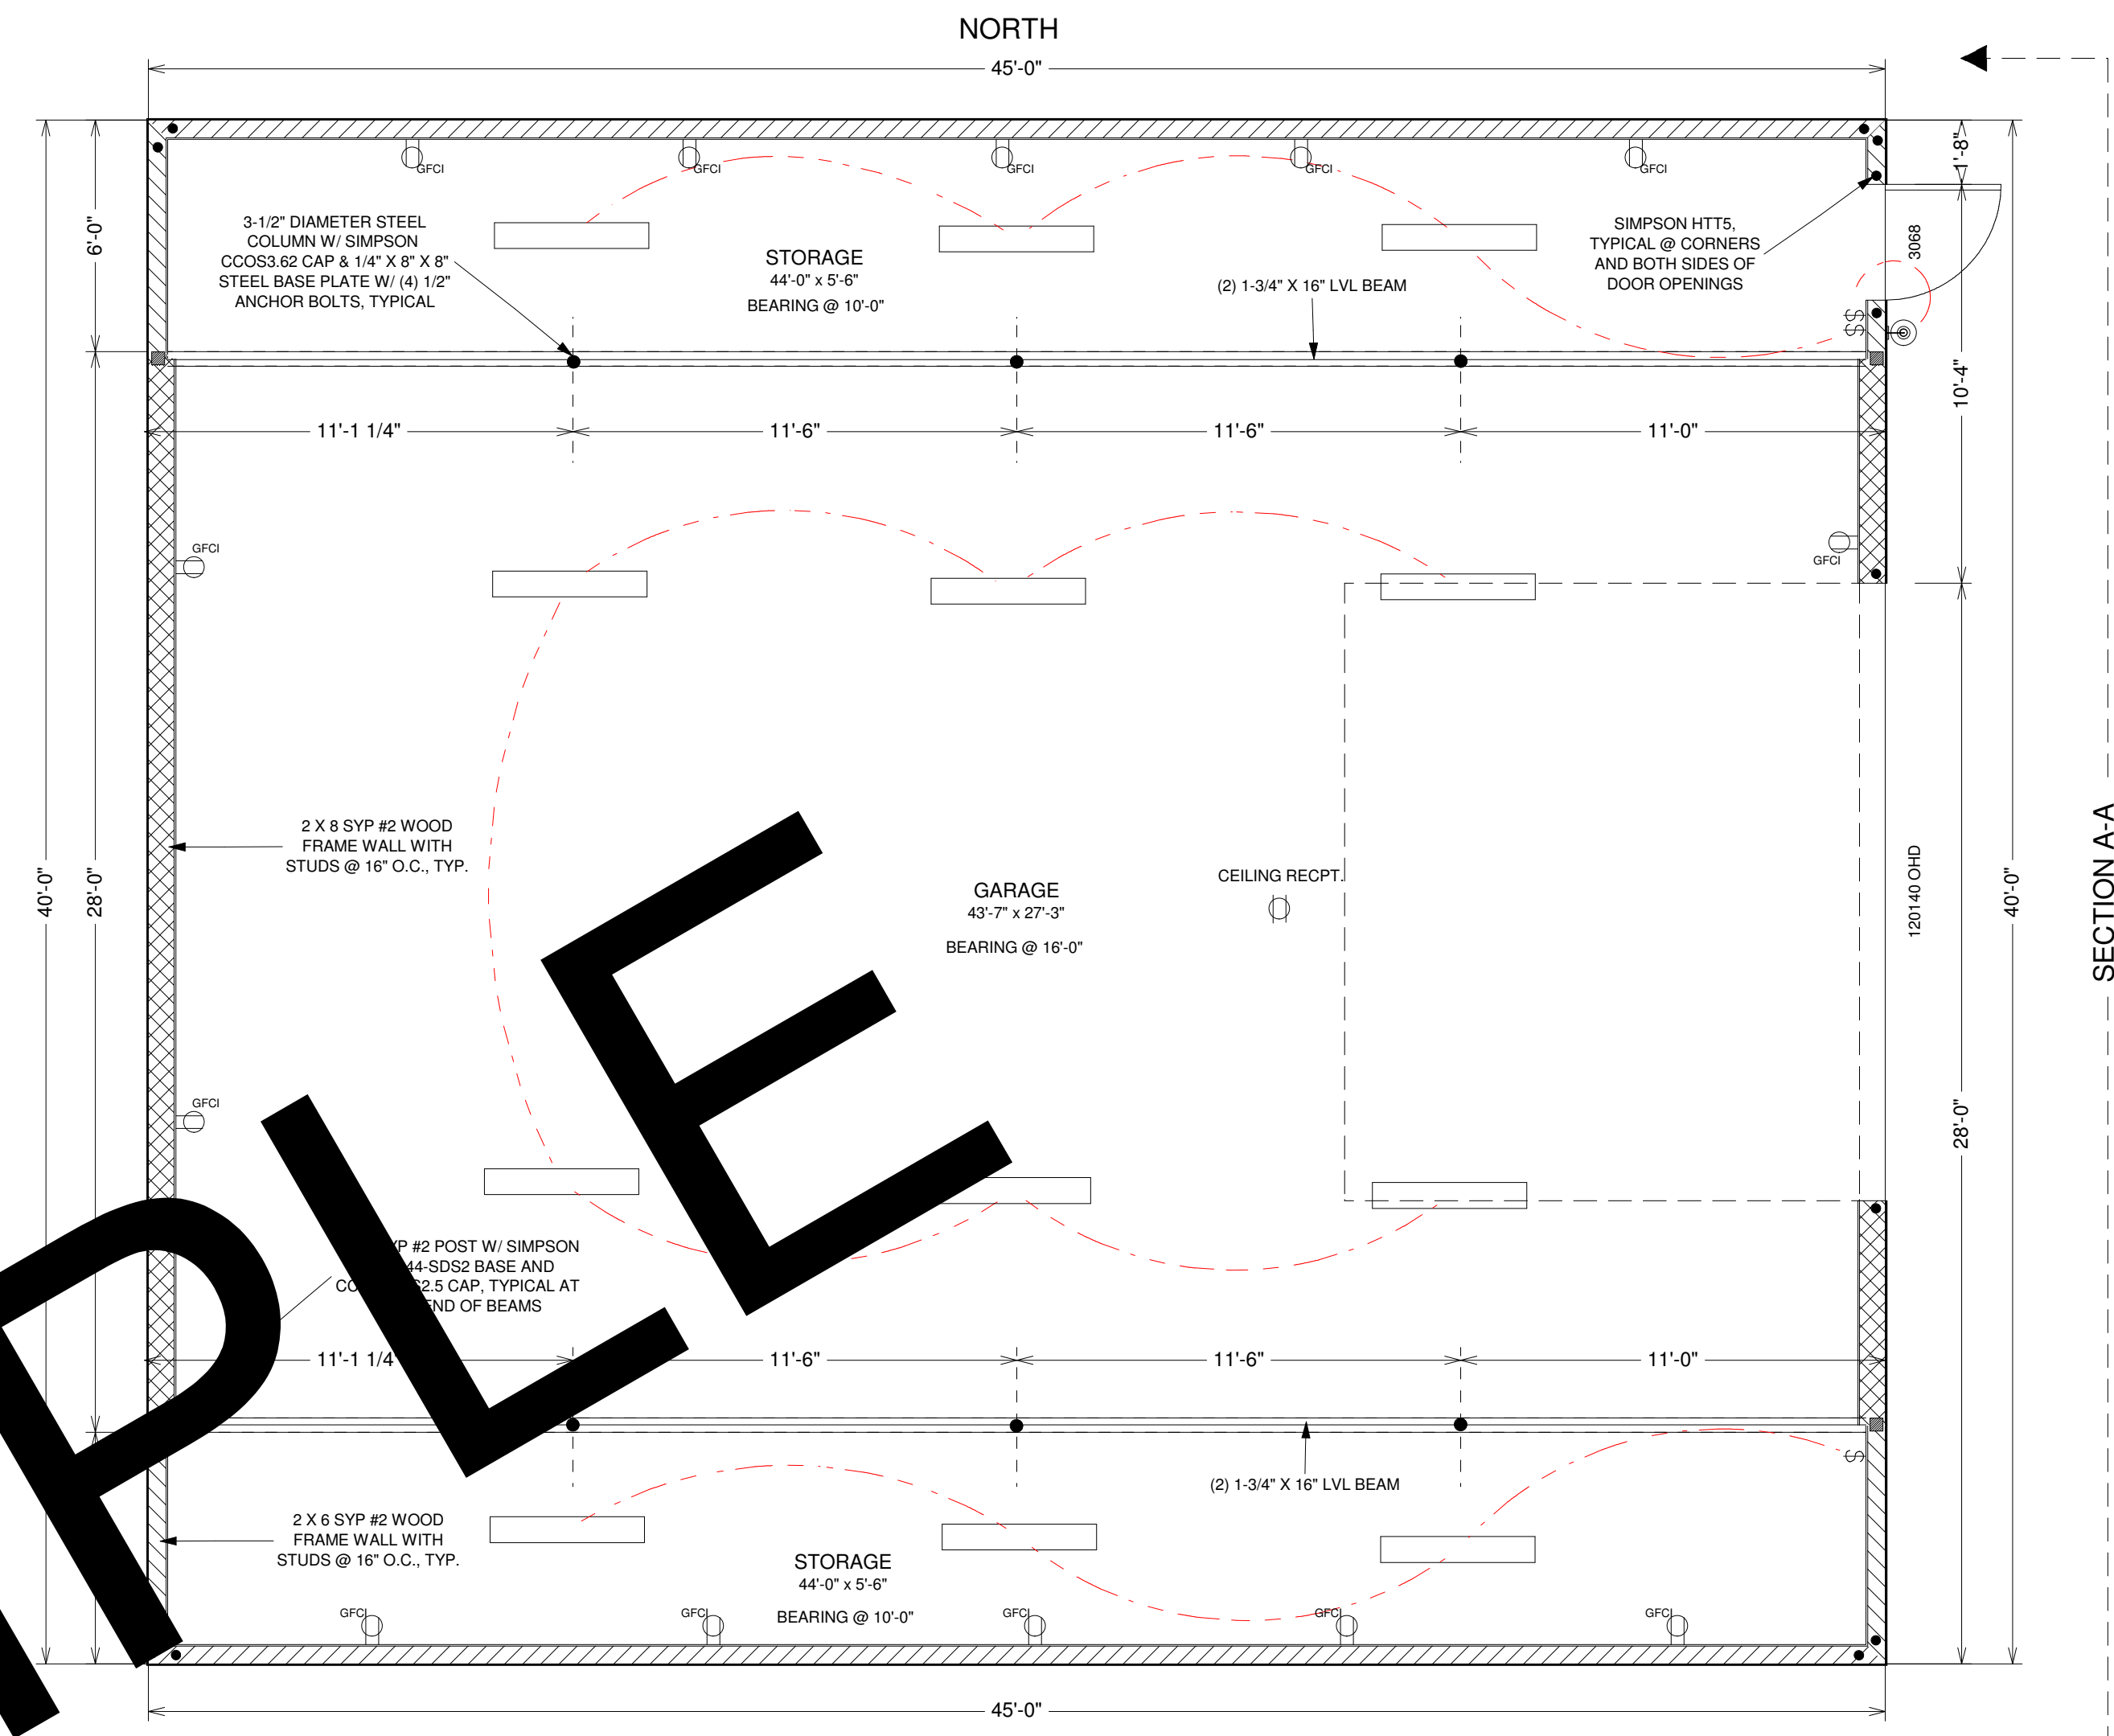


FLOOR & ELECTRICAL PLAN  
SCALE: 1/4" = 1'-0"


GARAGE AREA  
1244 SQ FT  
STORAGE AREAS  
556 SQ FT  
TOTAL BUILDING AREA  
1800 SQ FT

ROOF NOTES:

LOWER ROOF STRUCTURE: 2 X 6 SYP #2 RAFTERS @ 24" O.C.  
UPPER ROOF STRUCTURE: 14" TJI 560 @ 16" O.C.  
ROOF COVERING: MEMBRANE, METAL OR SHINGLE ROOF (DOUBLE UNDERLAYMENT FOR SHINGLE)  
ROOF PITCH: 2/12  
OVERHANGS: 12"

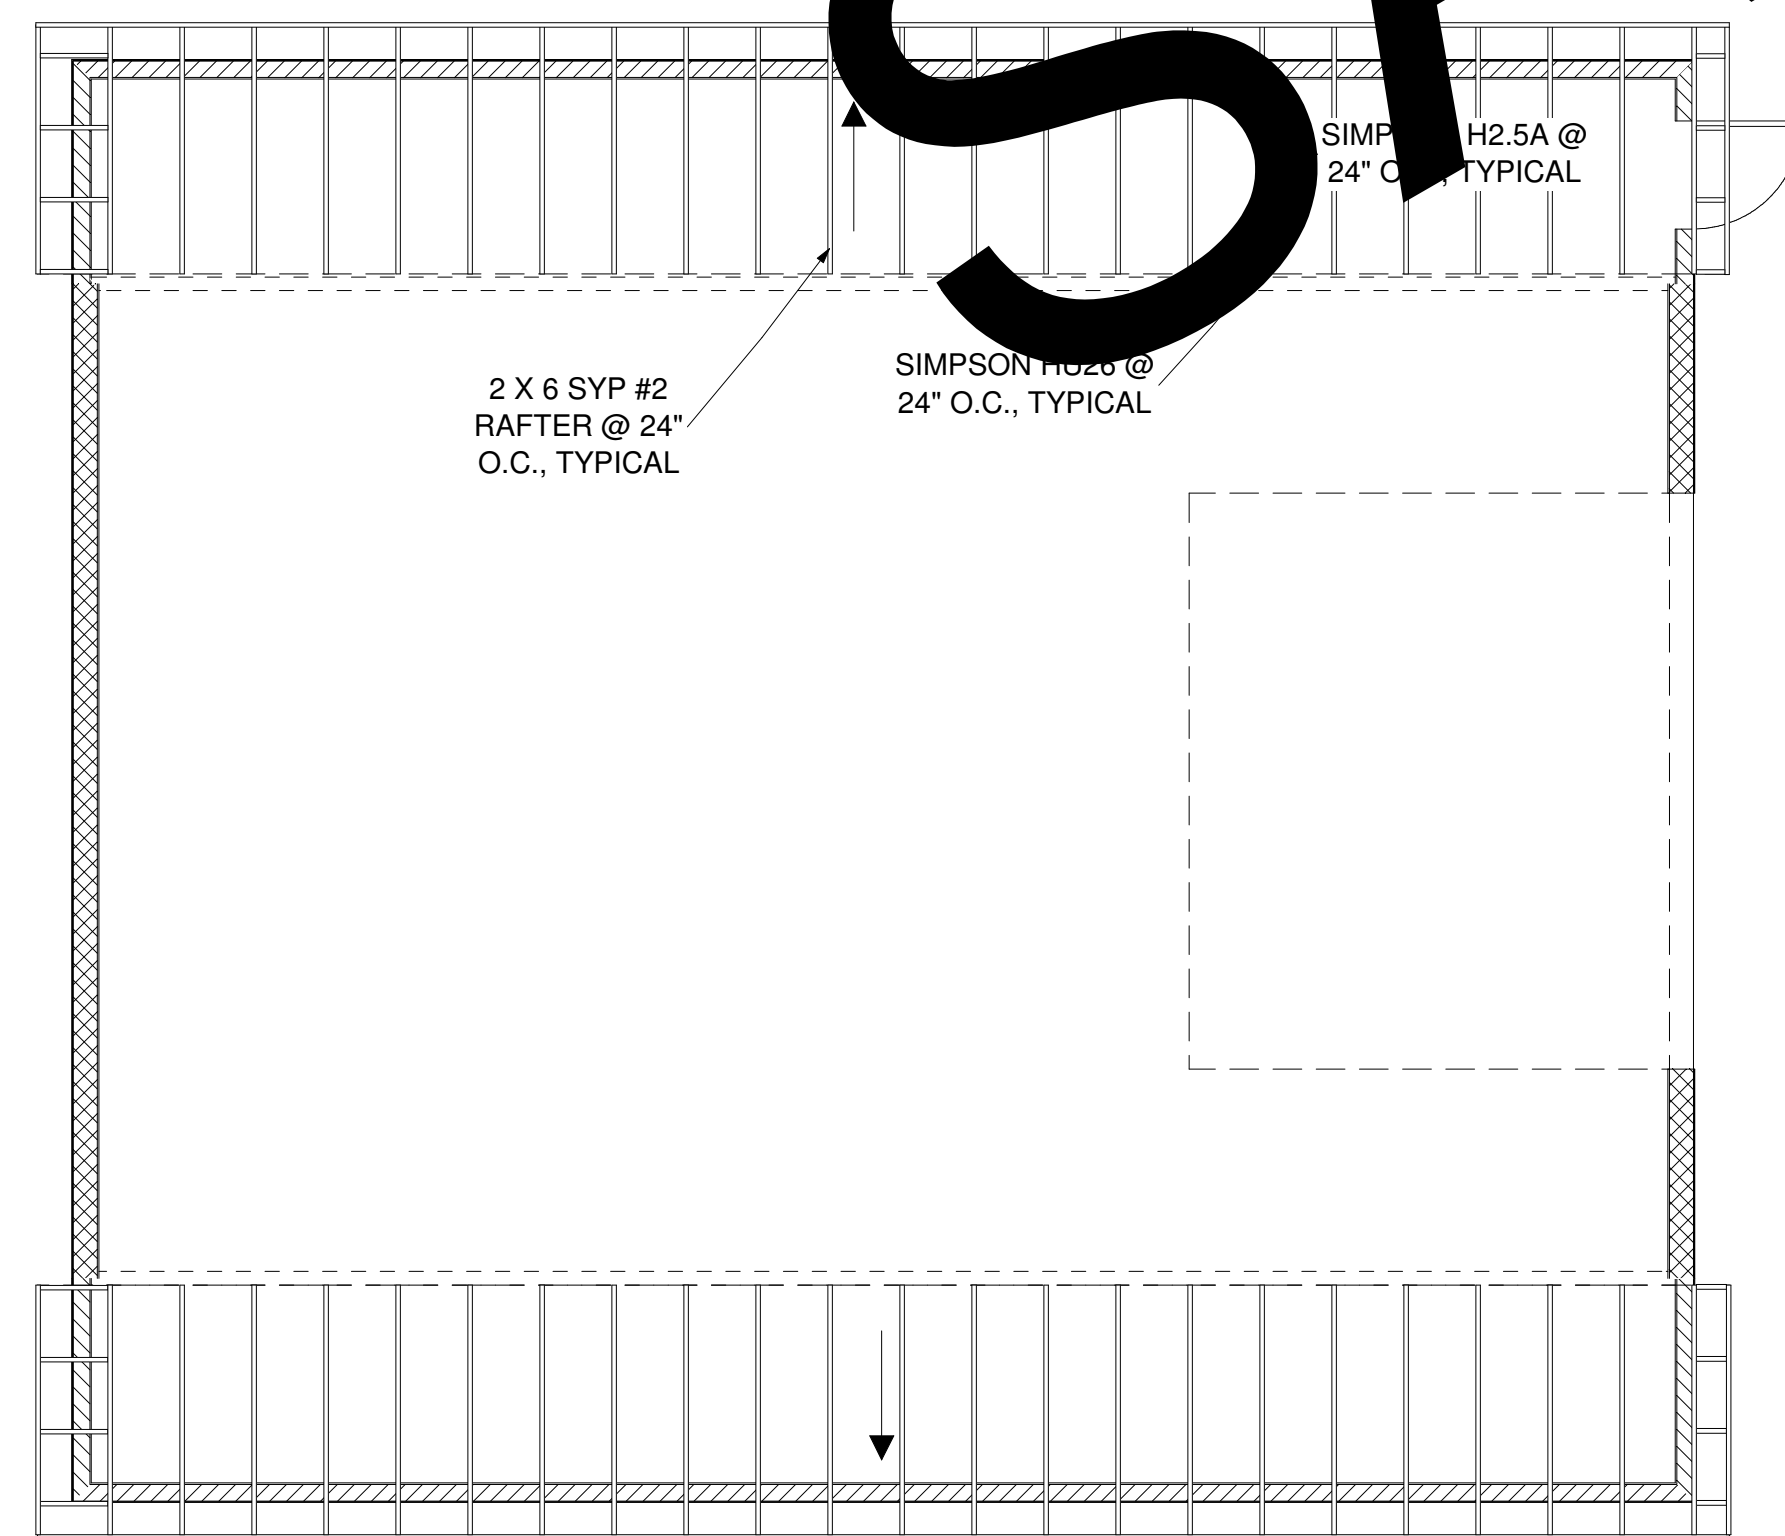

GROUND FLOOR ROOF PLAN  
SCALE: 3/16" = 1'-0"

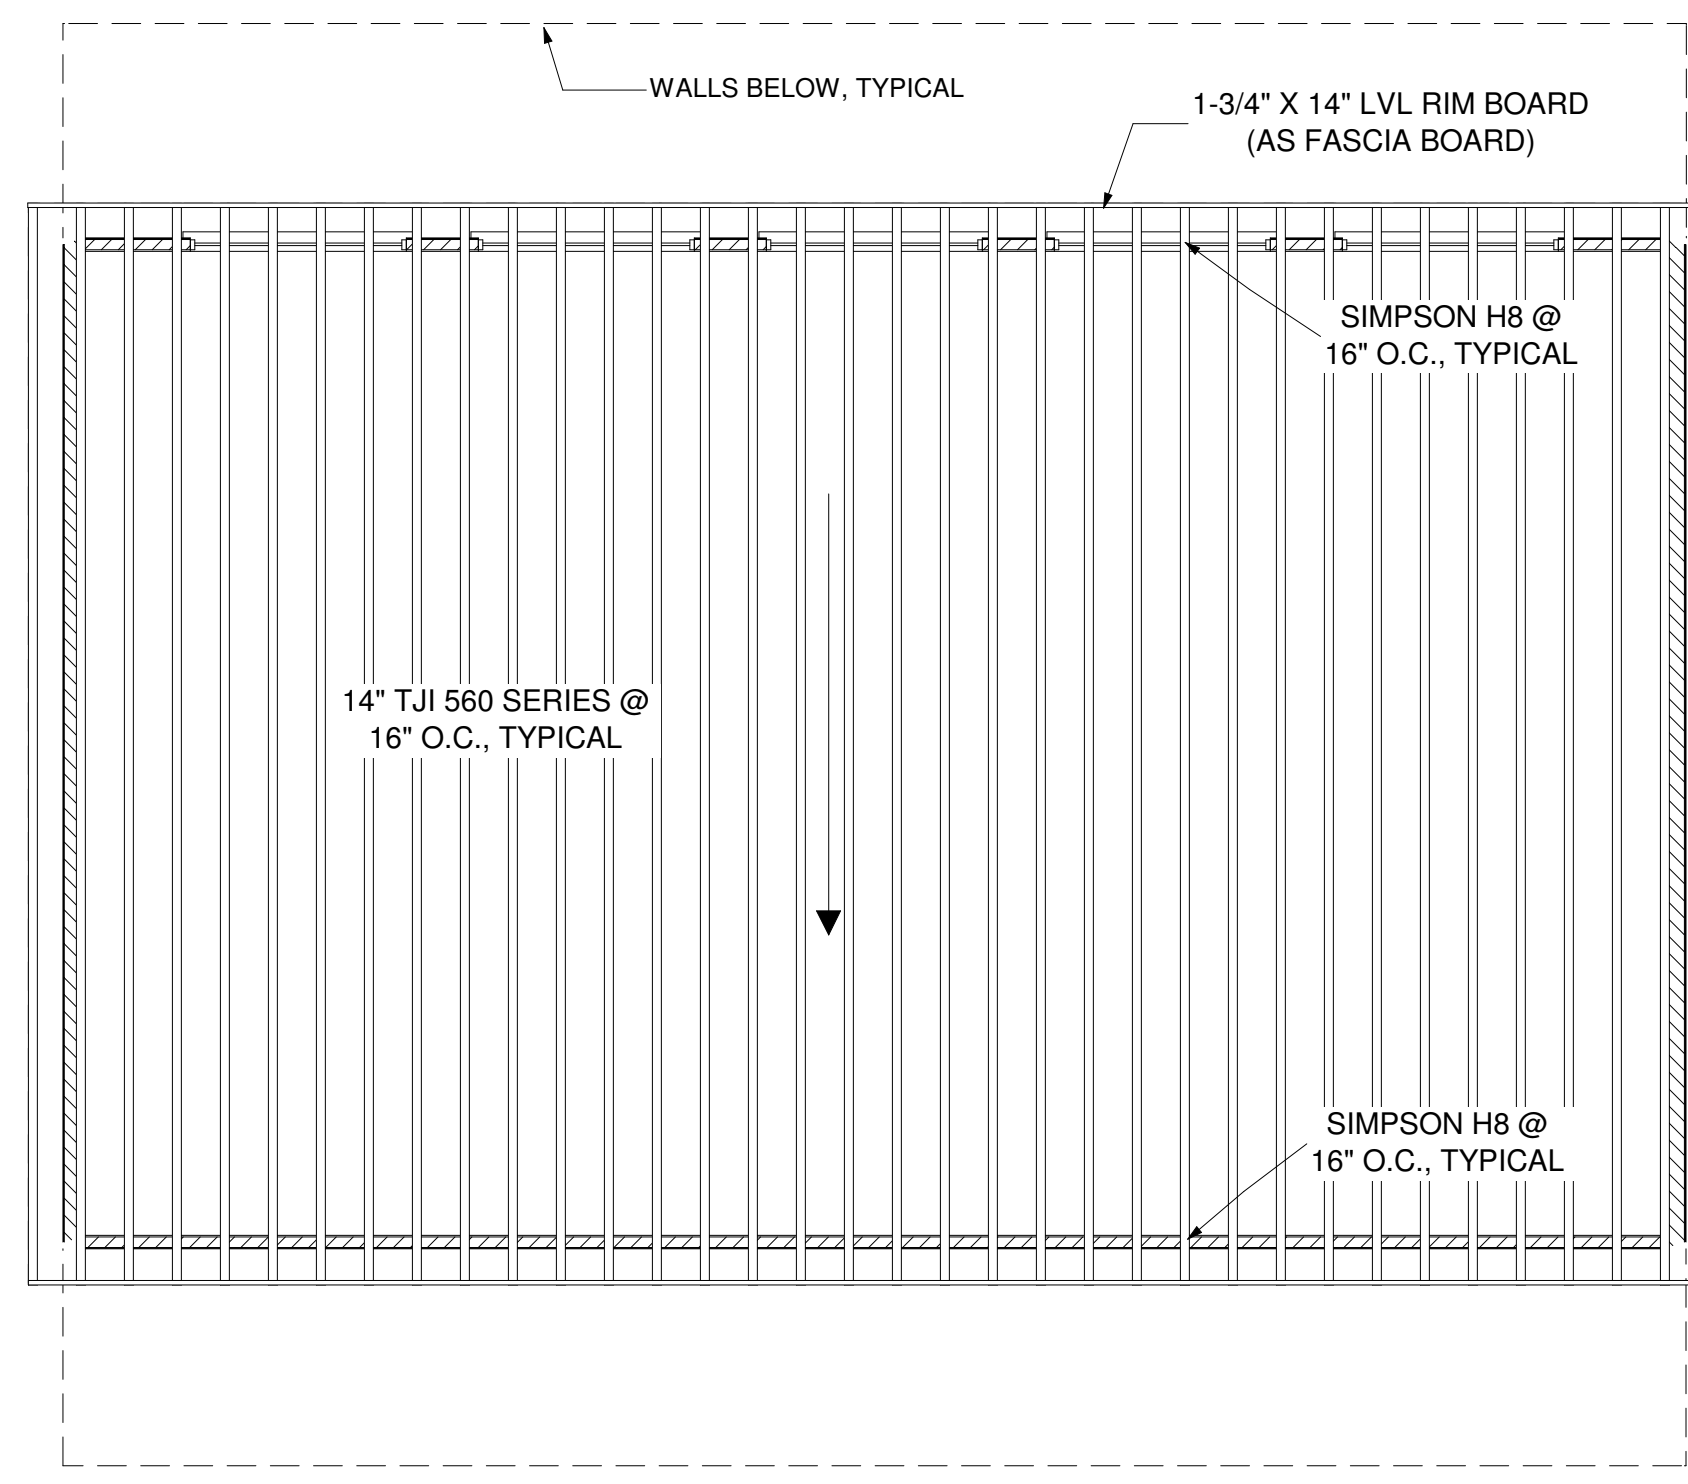


UPPER ROOF PLAN  
SCALE: 3/16" = 1'-0"


NOTE: THIS PLAN IS DESIGNED IN COMPLIANCE WITH THE FLORIDA BUILDING CODE 2014, 5TH EDITION.

THIS DESIGN IS THE INTELLECTUAL PROPERTY OF DREAMCATCHER BUILDING DESIGNS. IT IS NOT TO BE REPRODUCED OR REUSED WITHOUT THE EXPRESS CONSENT OF DREAMCATCHER BUILDING DESIGNS.


SAMPLE RV GARAGE  
BRADENTON, FLORIDA

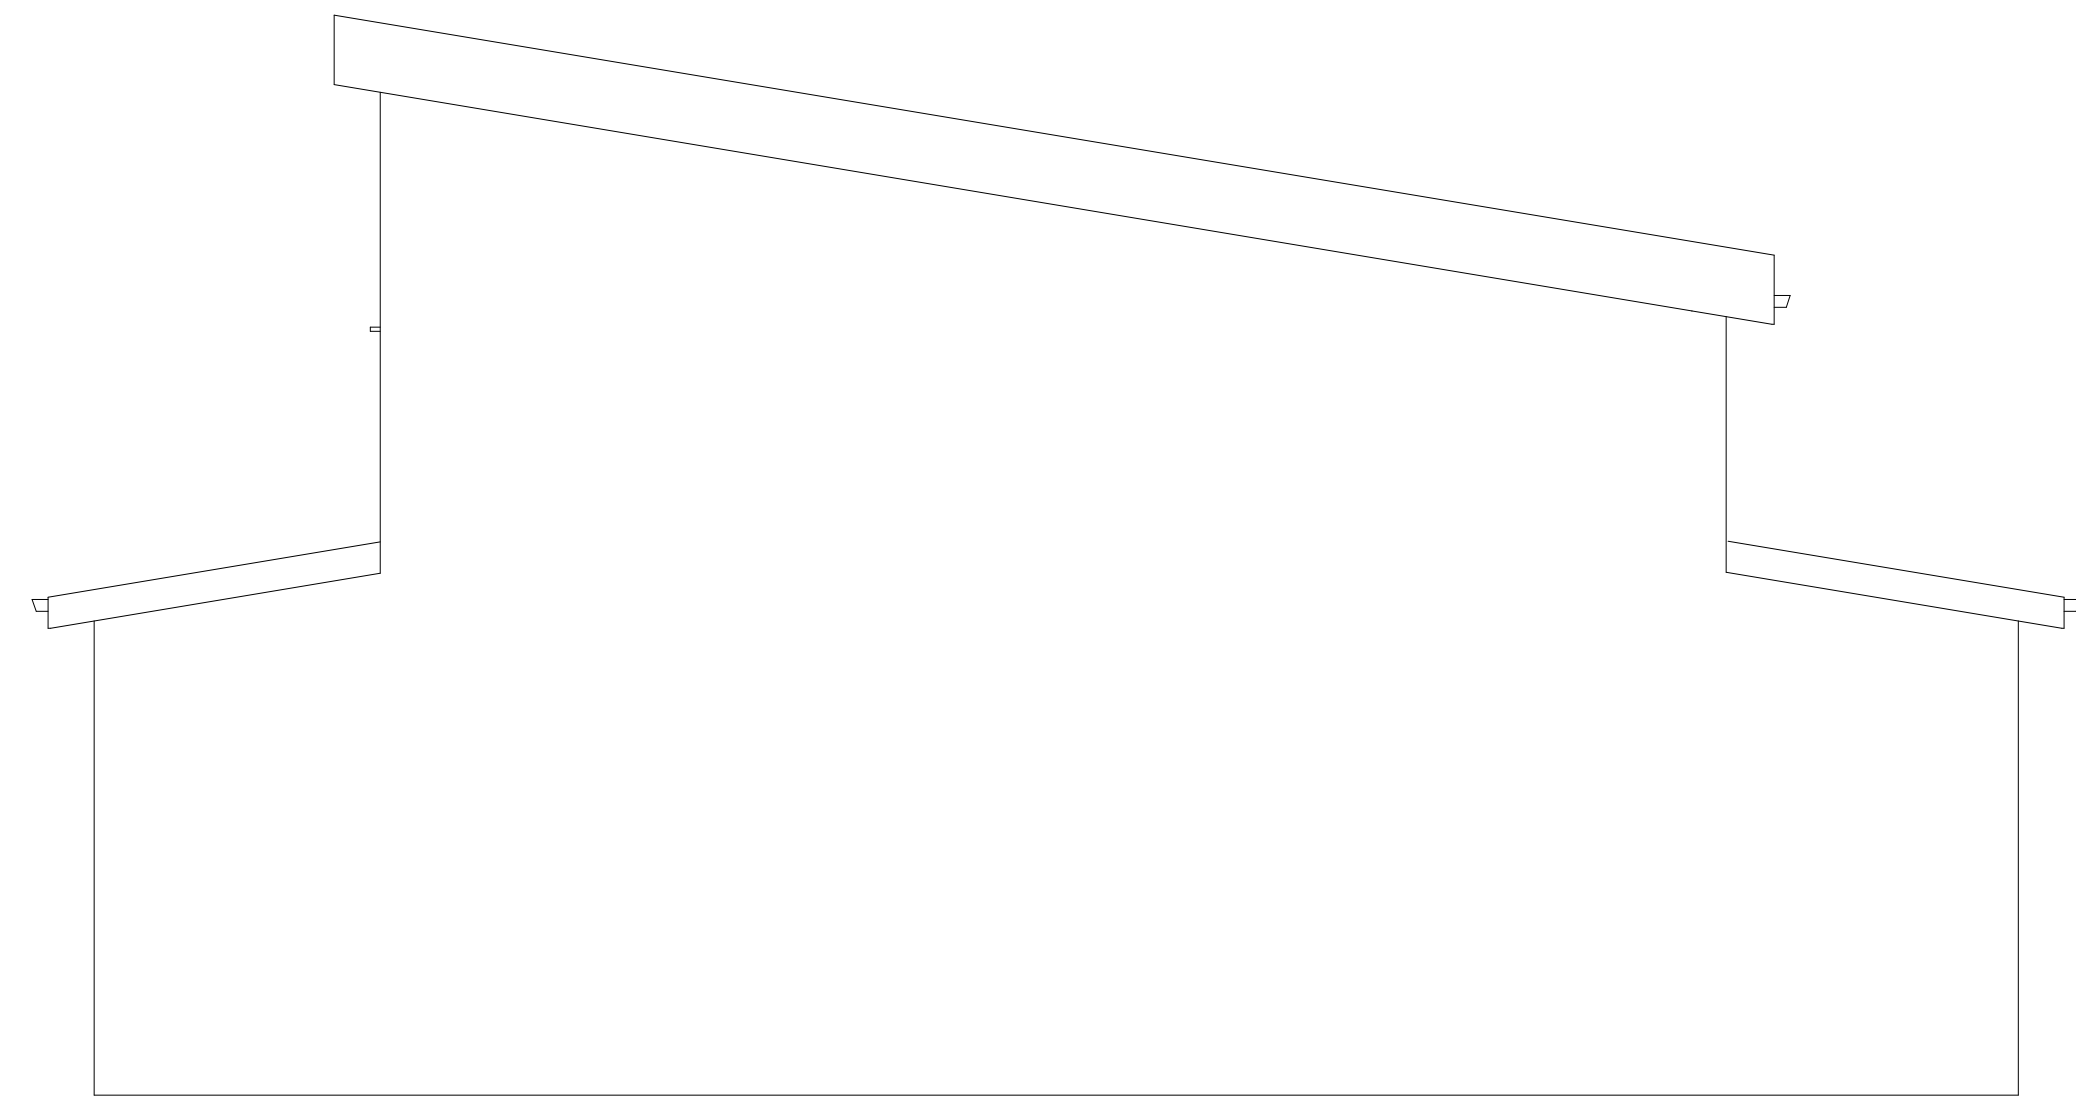

WEST ELEVATION  
SCALE: 1/4" = 1'-0"

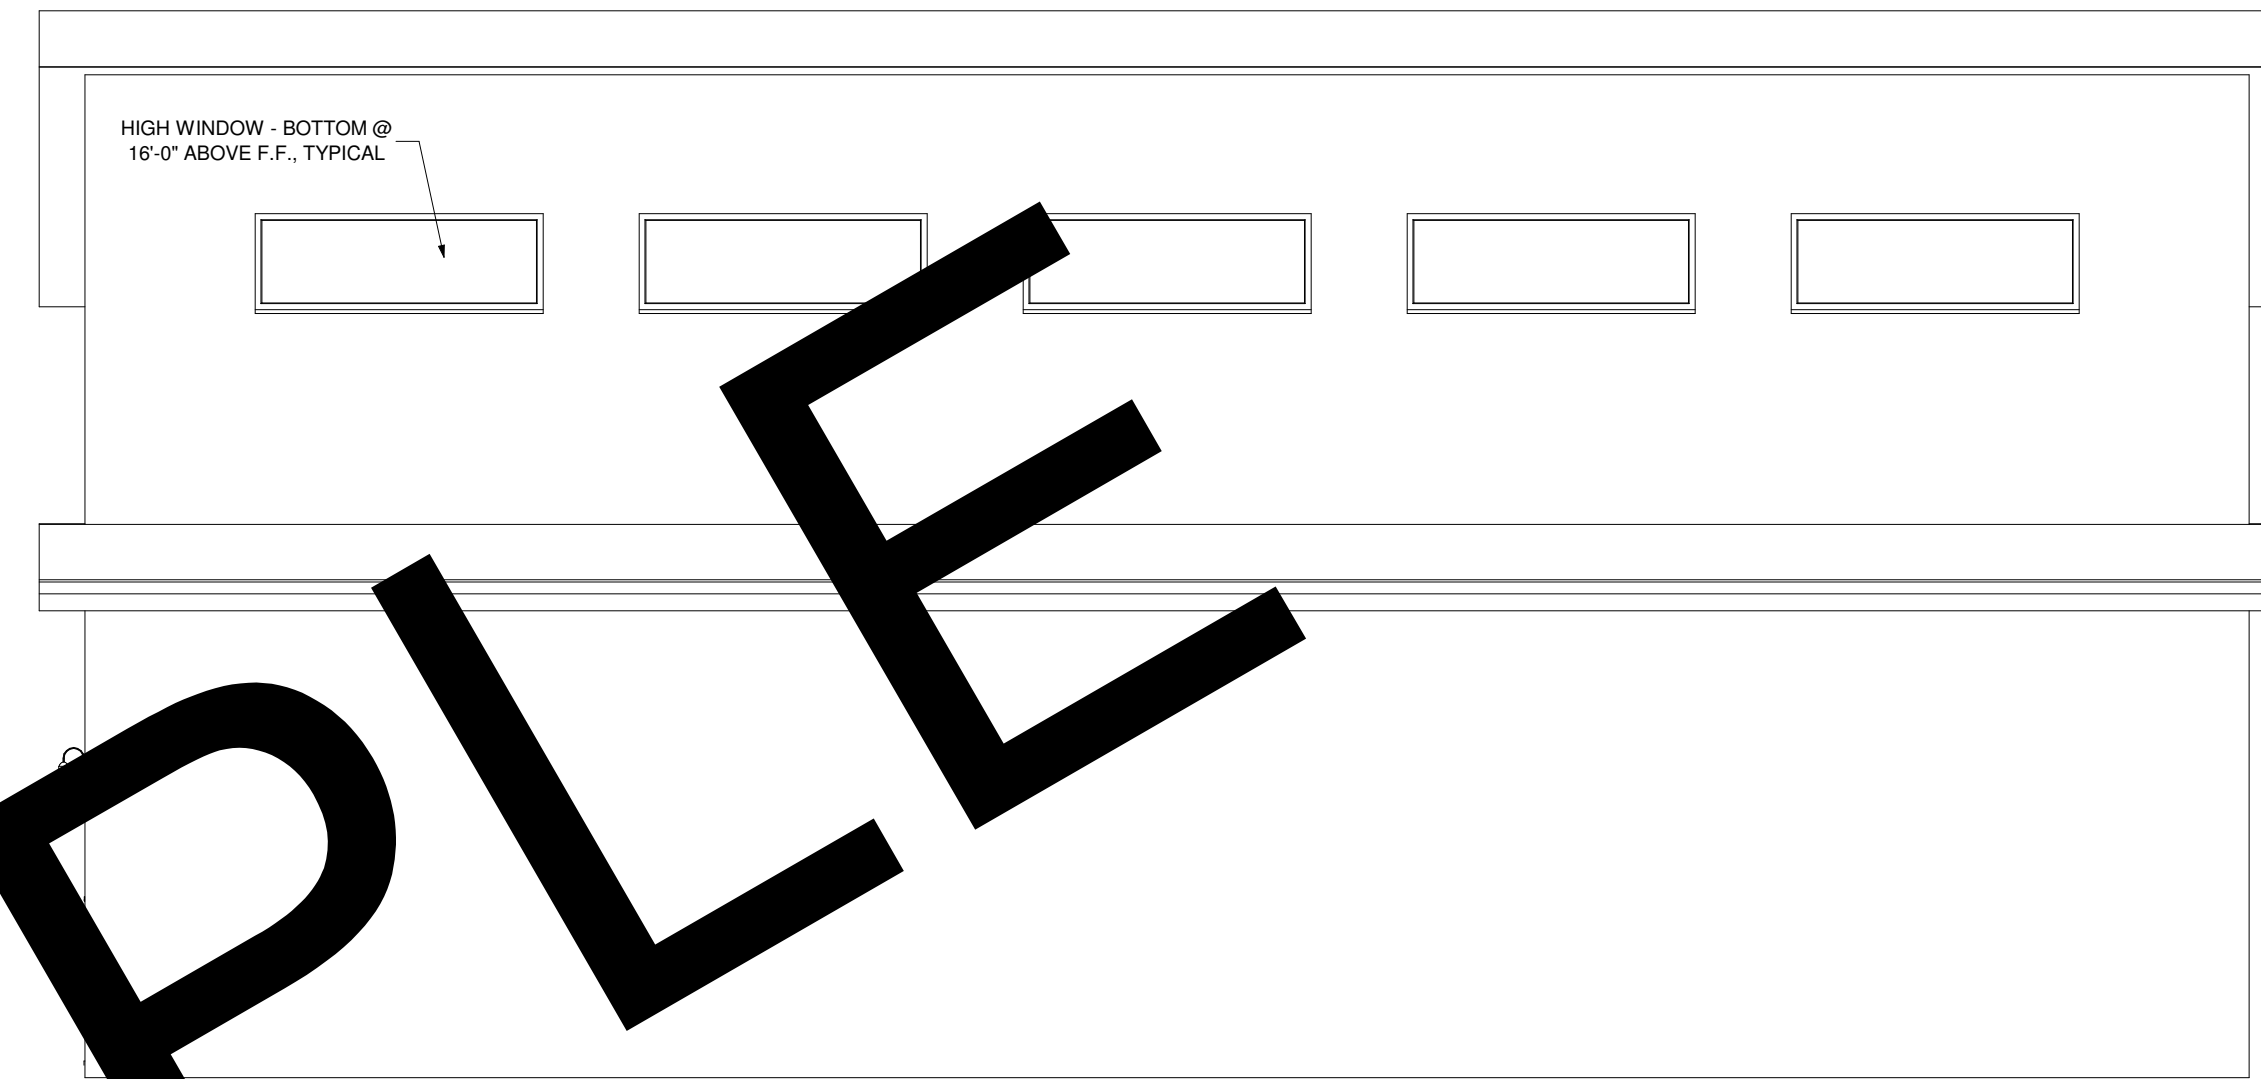

NORTH ELEVATION  
SCALE: 1/4" = 1'-0"

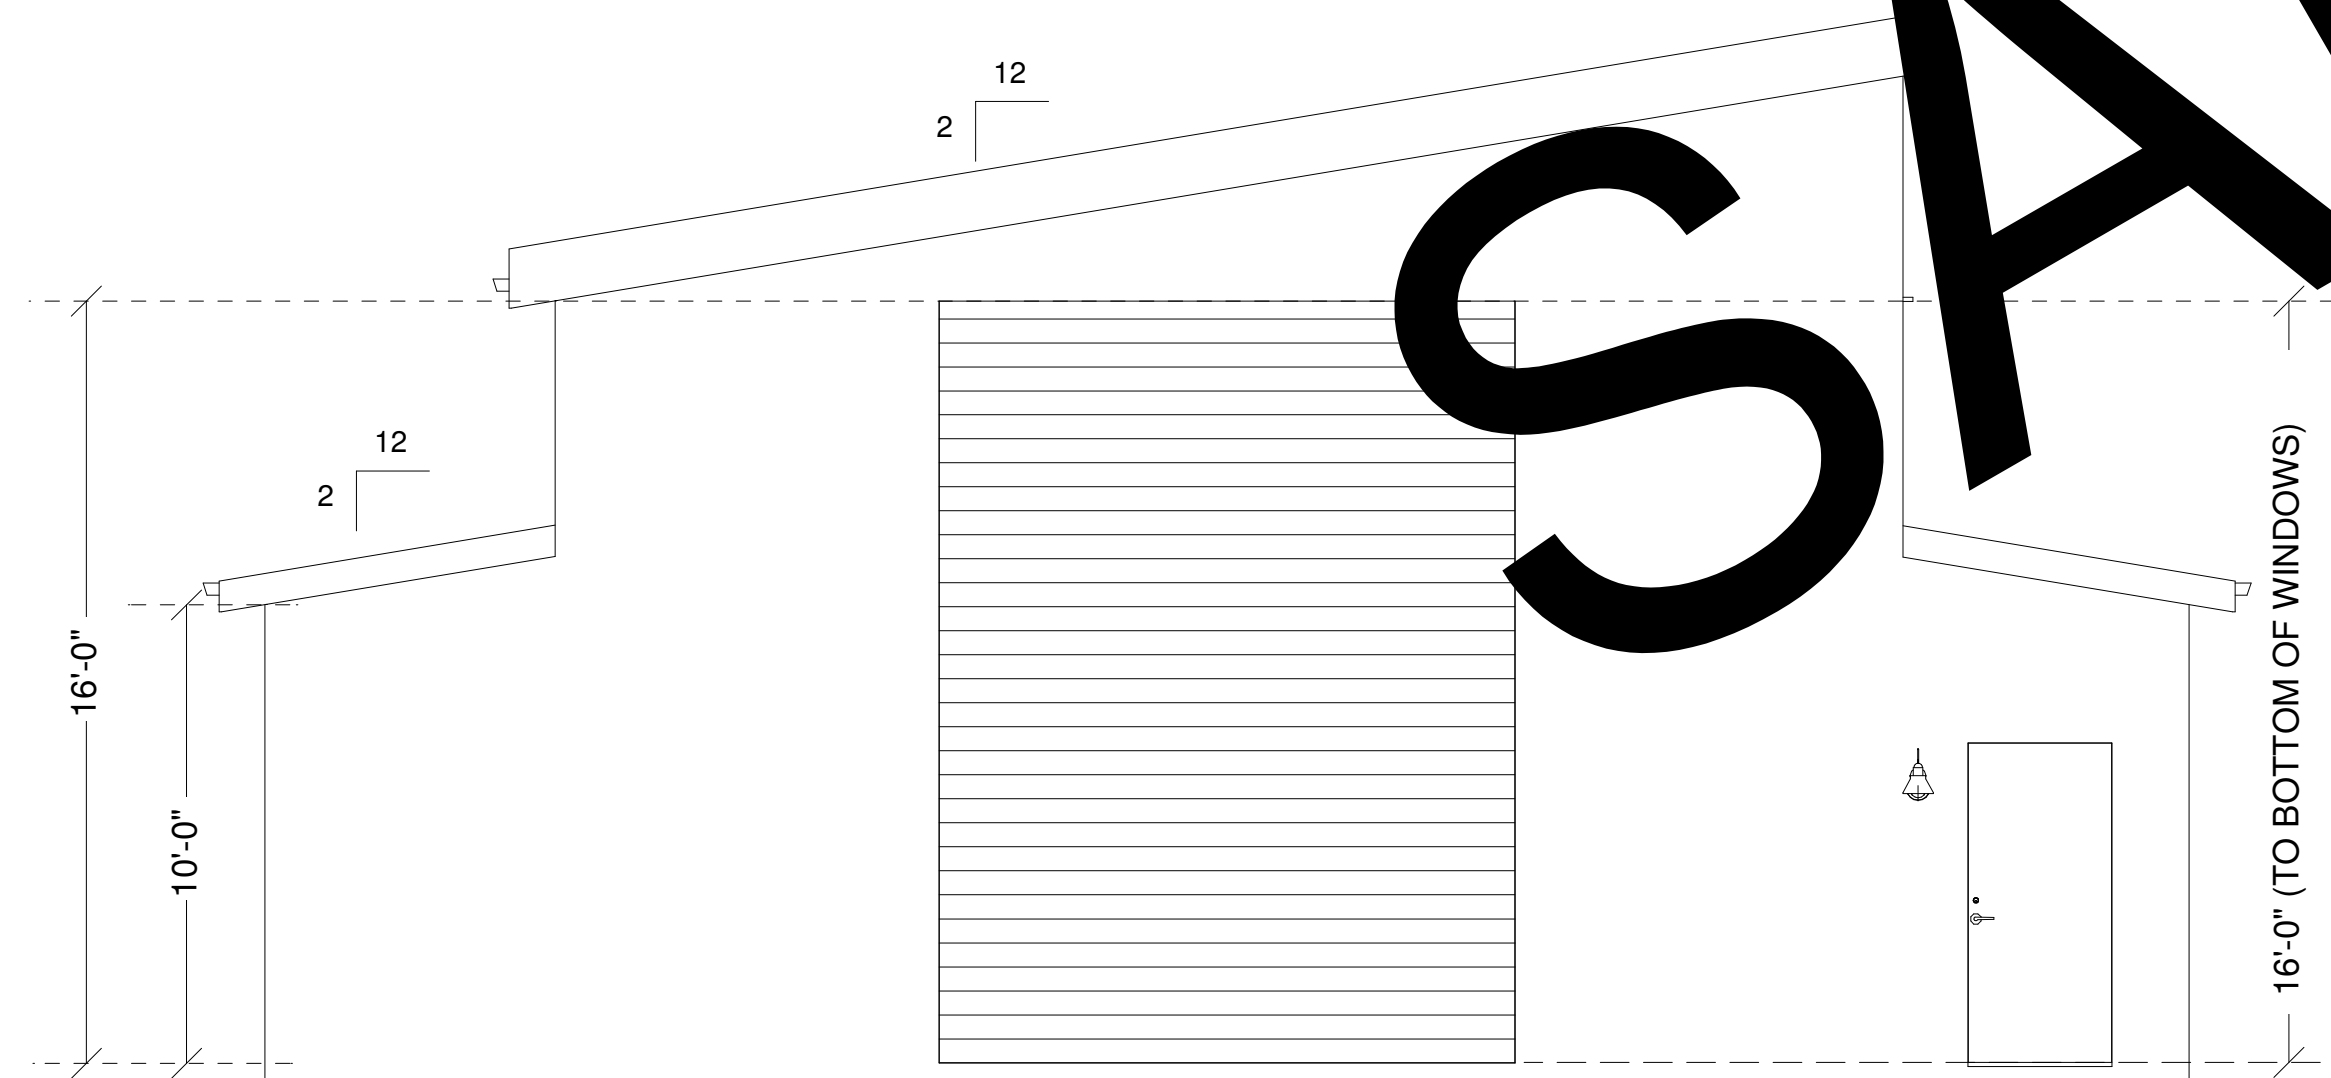

EAST ELEVATION  
SCALE: 1/4" = 1'-0"



SOUTH ELEVATION  
SCALE: 1/4" = 1'-0"

**SAMPLE**

THIS DESIGN IS THE INTELLECTUAL PROPERTY OF DREAMCATCHER BUILDING DESIGNS. IT IS NOT TO BE REPRODUCED OR REUSED WITHOUT THE EXPRESS CONSENT OF DREAMCATCHER BUILDING DESIGNS.

SAMPLE RV GARAGE  
BRADENTON, FLORIDA

