


THIS DESIGN IS THE INTELLECTUAL PROPERTY OF DREAMCATCHER BUILDING DESIGNS AND IS NOT TO BE USED OR REPRODUCED WITHOUT THE EXPRESS WRITTEN CONSENT OF DREAMCATCHER BUILDING DESIGNS.

NEW HOME SAMPLE PLAN #1

Dreamcatcher Building Designs (941) 462-0110 www.DreamcatcherBuildingDesigns.com

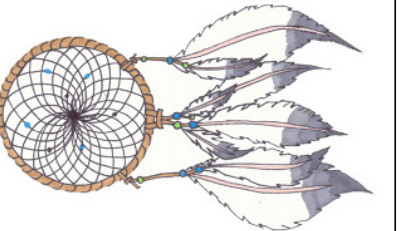

THIS BUILDING IS DESIGNED IN ACCORDANCE WITH THE FLORIDA BUILDING CODE 2014 EDITION. IT IS THE RESPONSIBILITY OF THE CONTRACTOR TO VERIFY ALL ASPECTS AND DIMENSIONS ON THIS PLAN PRIOR TO THE START OF CONSTRUCTION.

SCOPE OF PROJECT:


THESE PLANS ARE THE INTERIOR BUILD-OUT AND FOUNDATION DRAWINGS FOR THE ROUSHIA RESIDENCE TO BE BUILT INSIDE OF A PRE-FABRICATED METAL BUILDING.

THE INTERIOR FRAMING DOES NOT BEAR THE WEIGHT OF OR CONNECT STRUCTURALLY TO THE METAL BUILDING. LOAD BEARING INTERIOR WALLS ARE FOR CEILING JOIST BEARING ONLY.

STRUCTURAL DRAWINGS FOR THE METAL BUILDING ITSELF ARE BY OTHERS AND THE RESPONSIBILITY OF THE METAL BUILDING FABRICATOR/INSTALLER.


EXPOSURE CATEGORY: C
RISK CATEGORY: 2
DESIGN WIND SPEED: 130 MPH, 150 MPH 3-SECOND GUST
BUILDING HEIGHT: 18'-0"
FLOOD ZONE: X
FINISHED FLOOR ELEVATION: 18" MINIMUM ABOVE THE CROWN OF THE ROAD

NOTE: WINDOW AND DOOR DESIGN PRESSURES ARE +25.3/-27.4 MINIMUM.

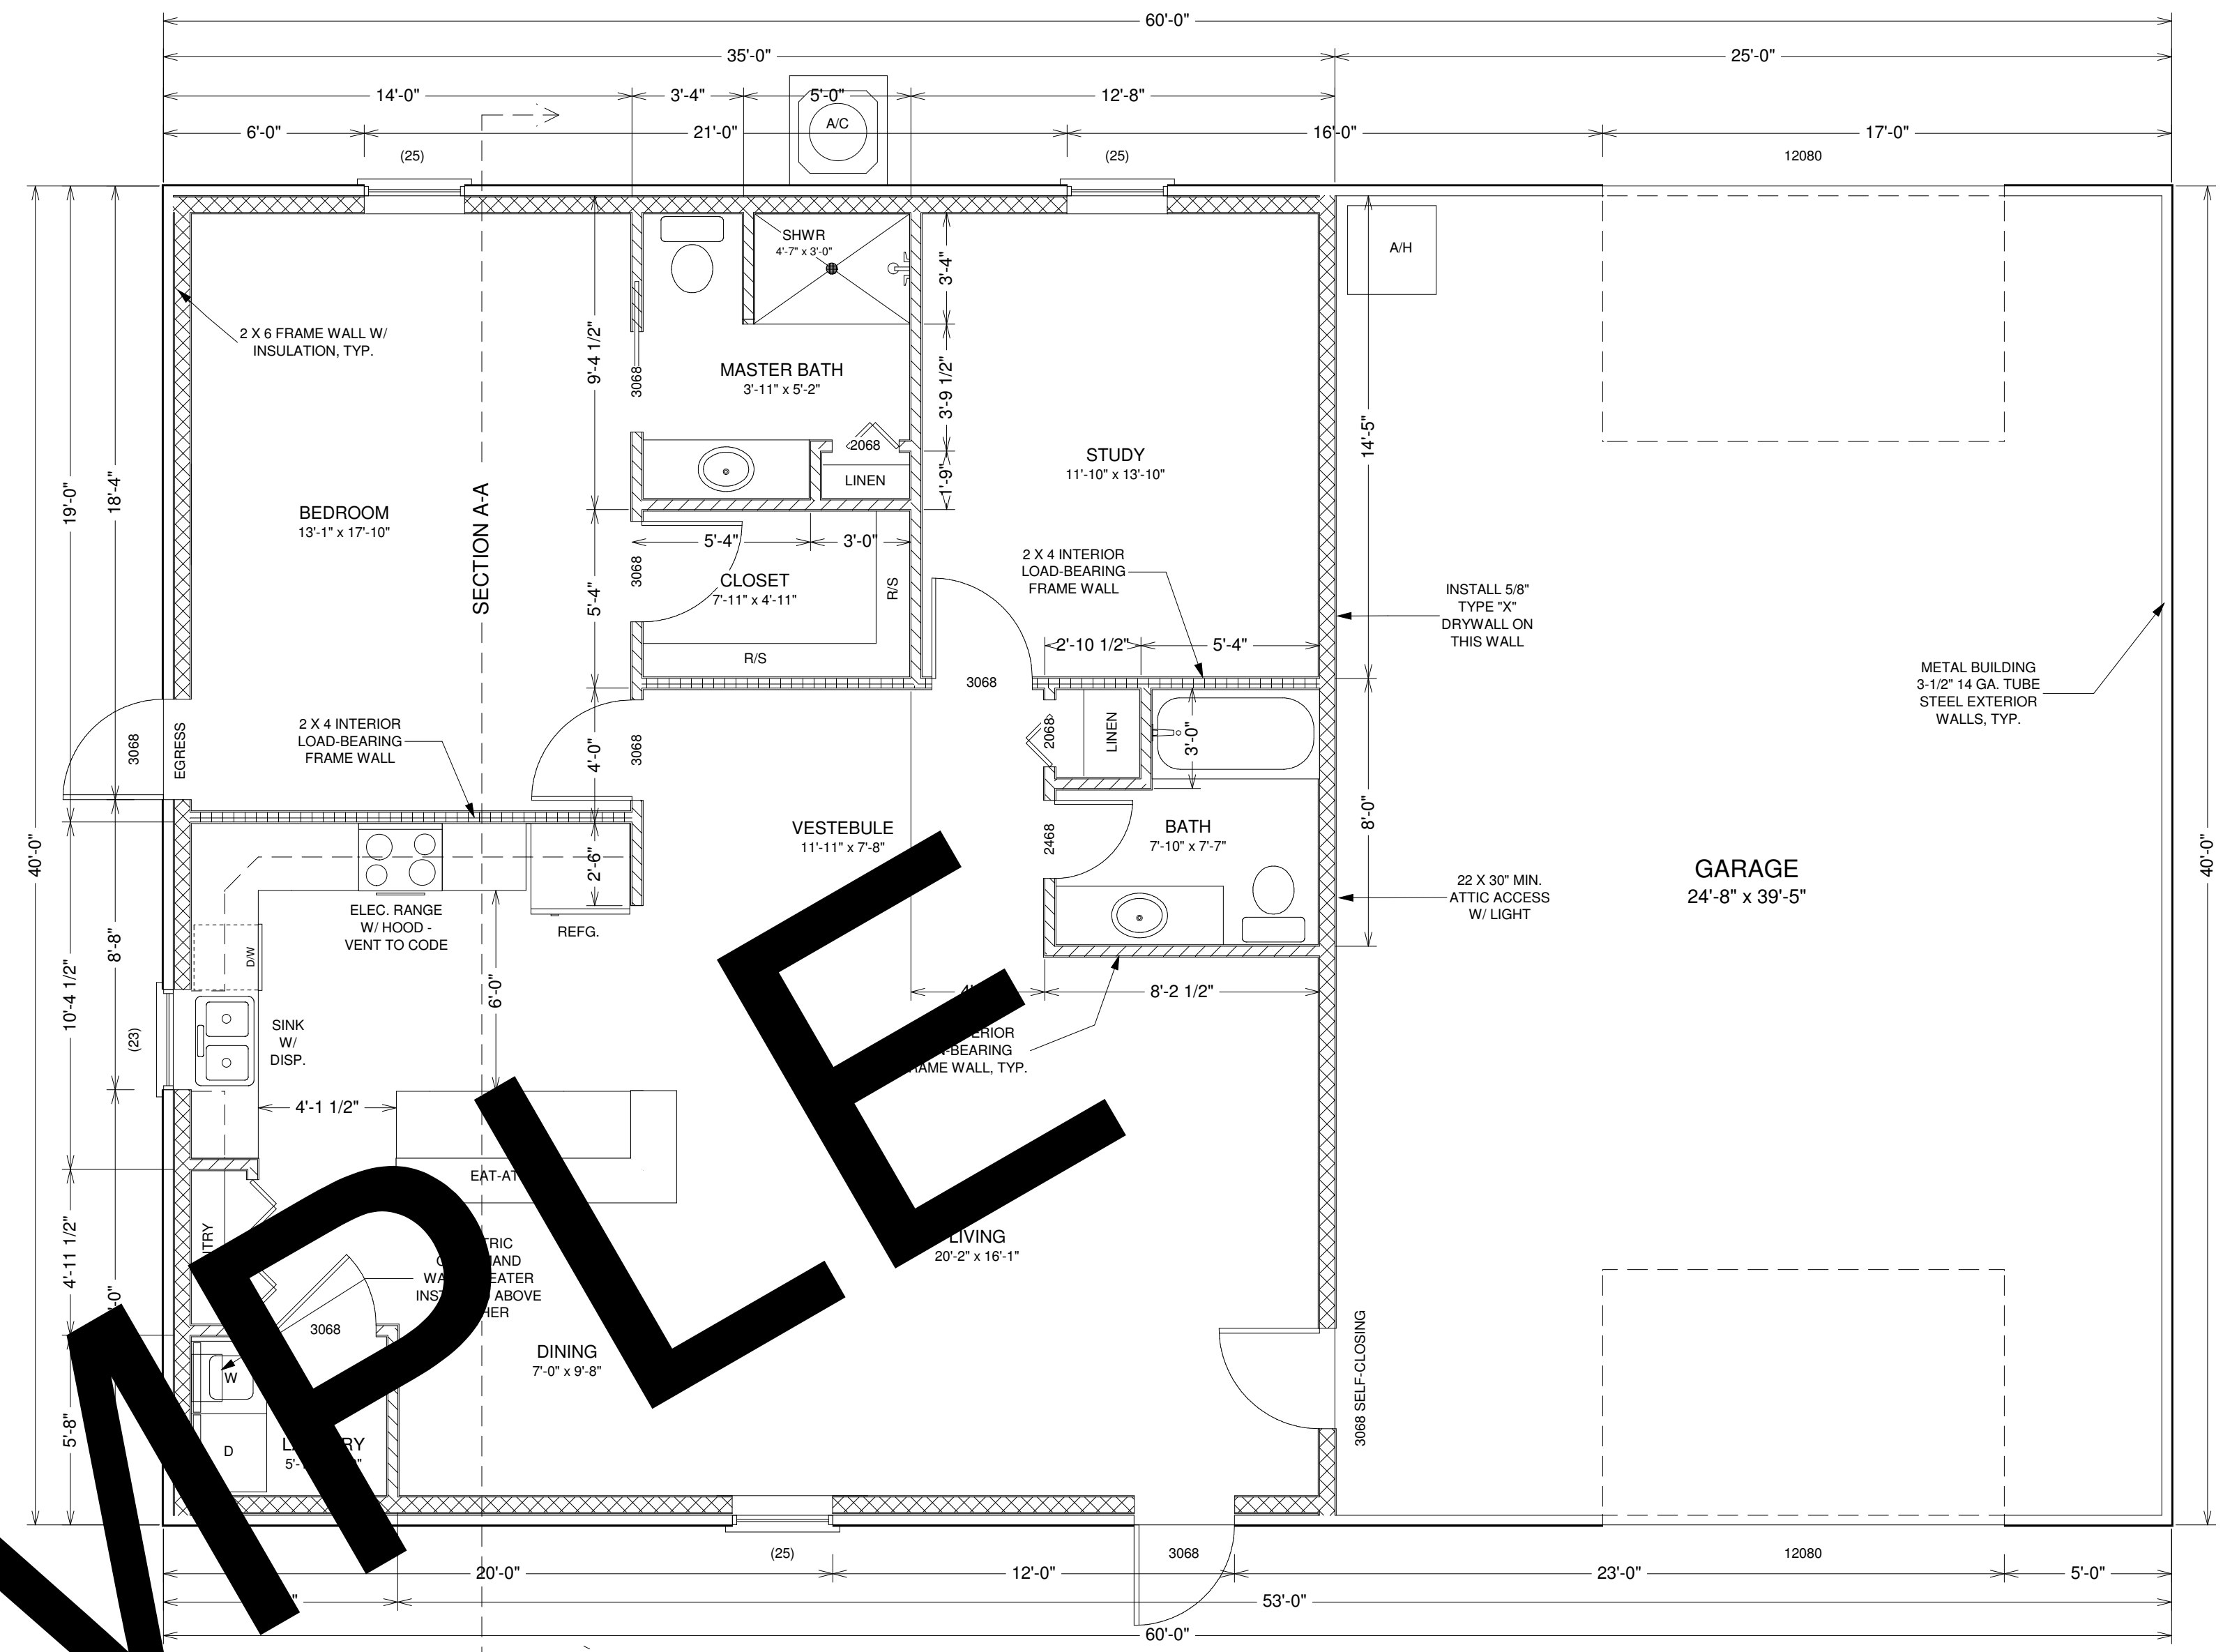

FLOOR PLAN SCALE: 1/4" = 1'-0"

LIVING AREA 1390 SQ FT
GARAGE AREA 1010 SQ FT
TOTAL AREA 2400 SQ FT


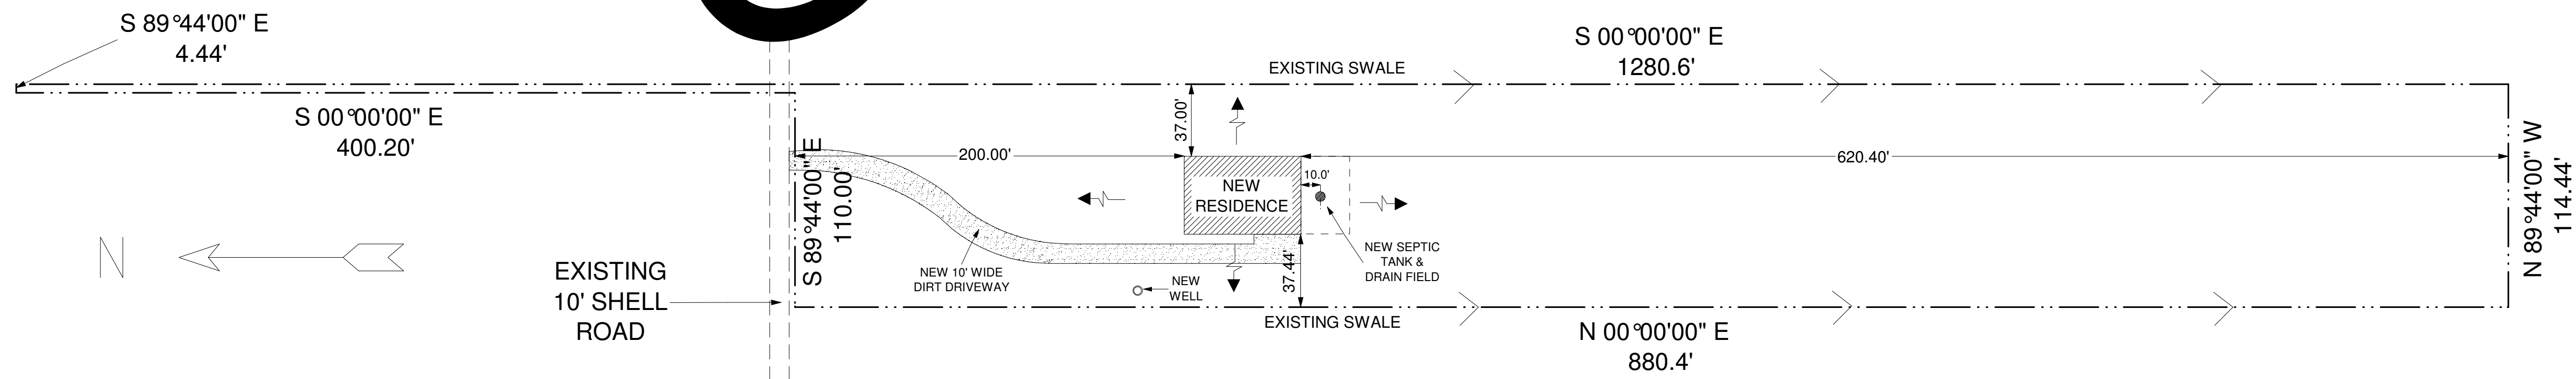


PLOT PLAN SCALE: 1/2" = 25'-0"


THIS DESIGN IS THE INTELLECTUAL PROPERTY OF DREAMCATCHER BUILDING DESIGNS AND IS NOT TO BE USED OR REPRODUCED WITHOUT THE EXPRESS WRITTEN CONSENT OF DREAMCATCHER BUILDING DESIGNS.

NEW HOME SAMPLE
PLAN #1


Dreamcatcher
Building Designs
(941) 462-0110
www.DreamcatcherBuildingDesigns.com

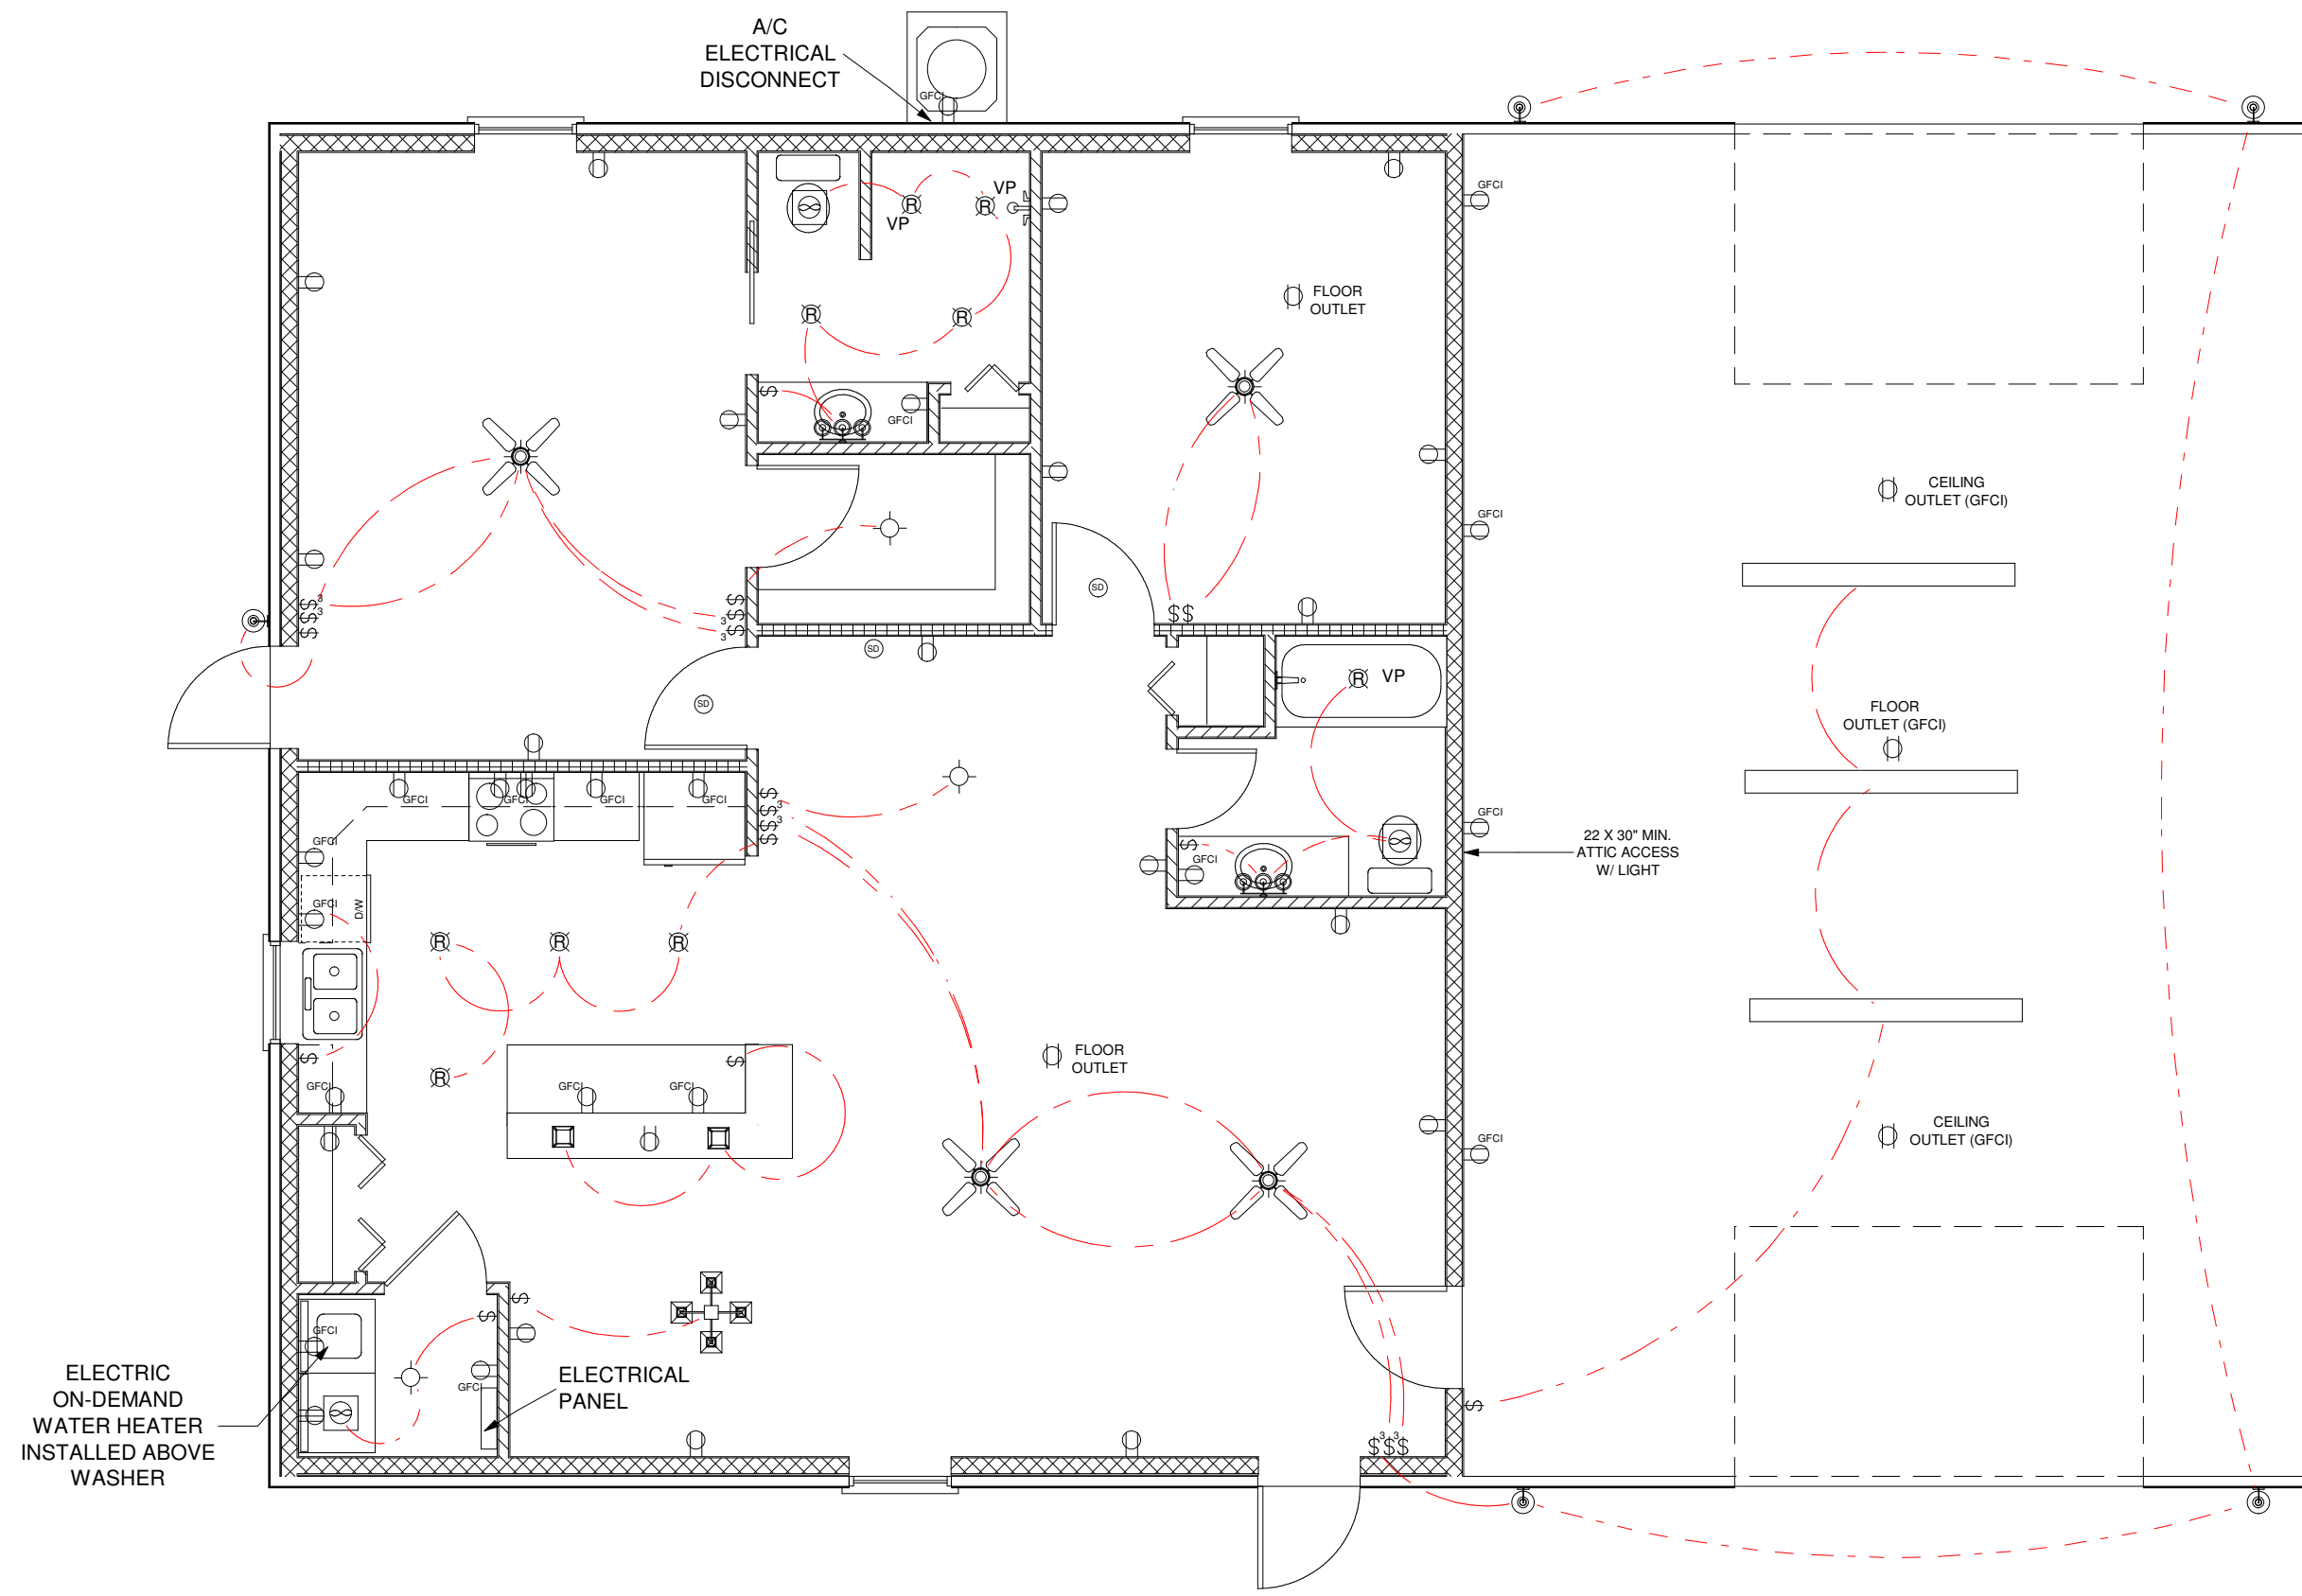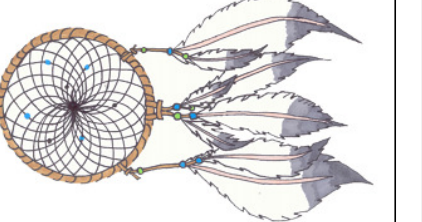


ELECTRICAL PLAN
SCALE: 3/16" = 1'-0"

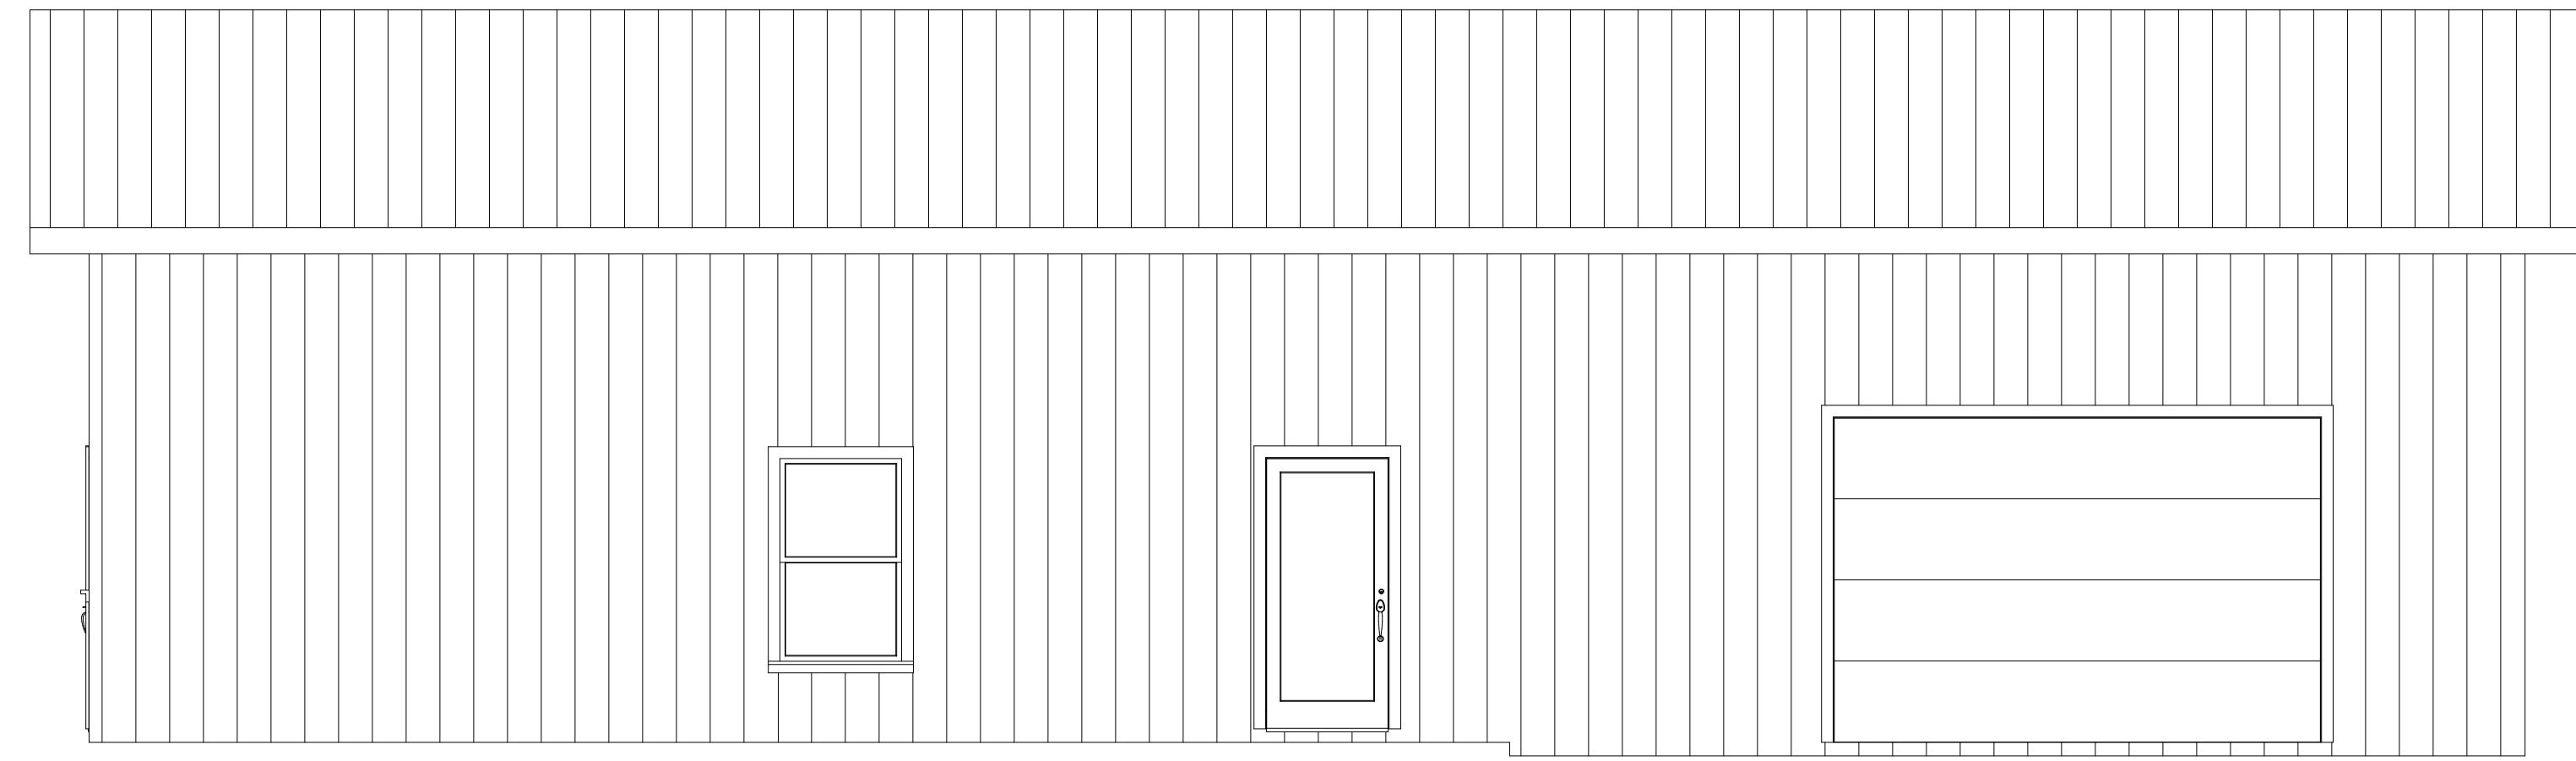


RIGHT ELEVATION
SCALE: 1/4" = 1'-0"

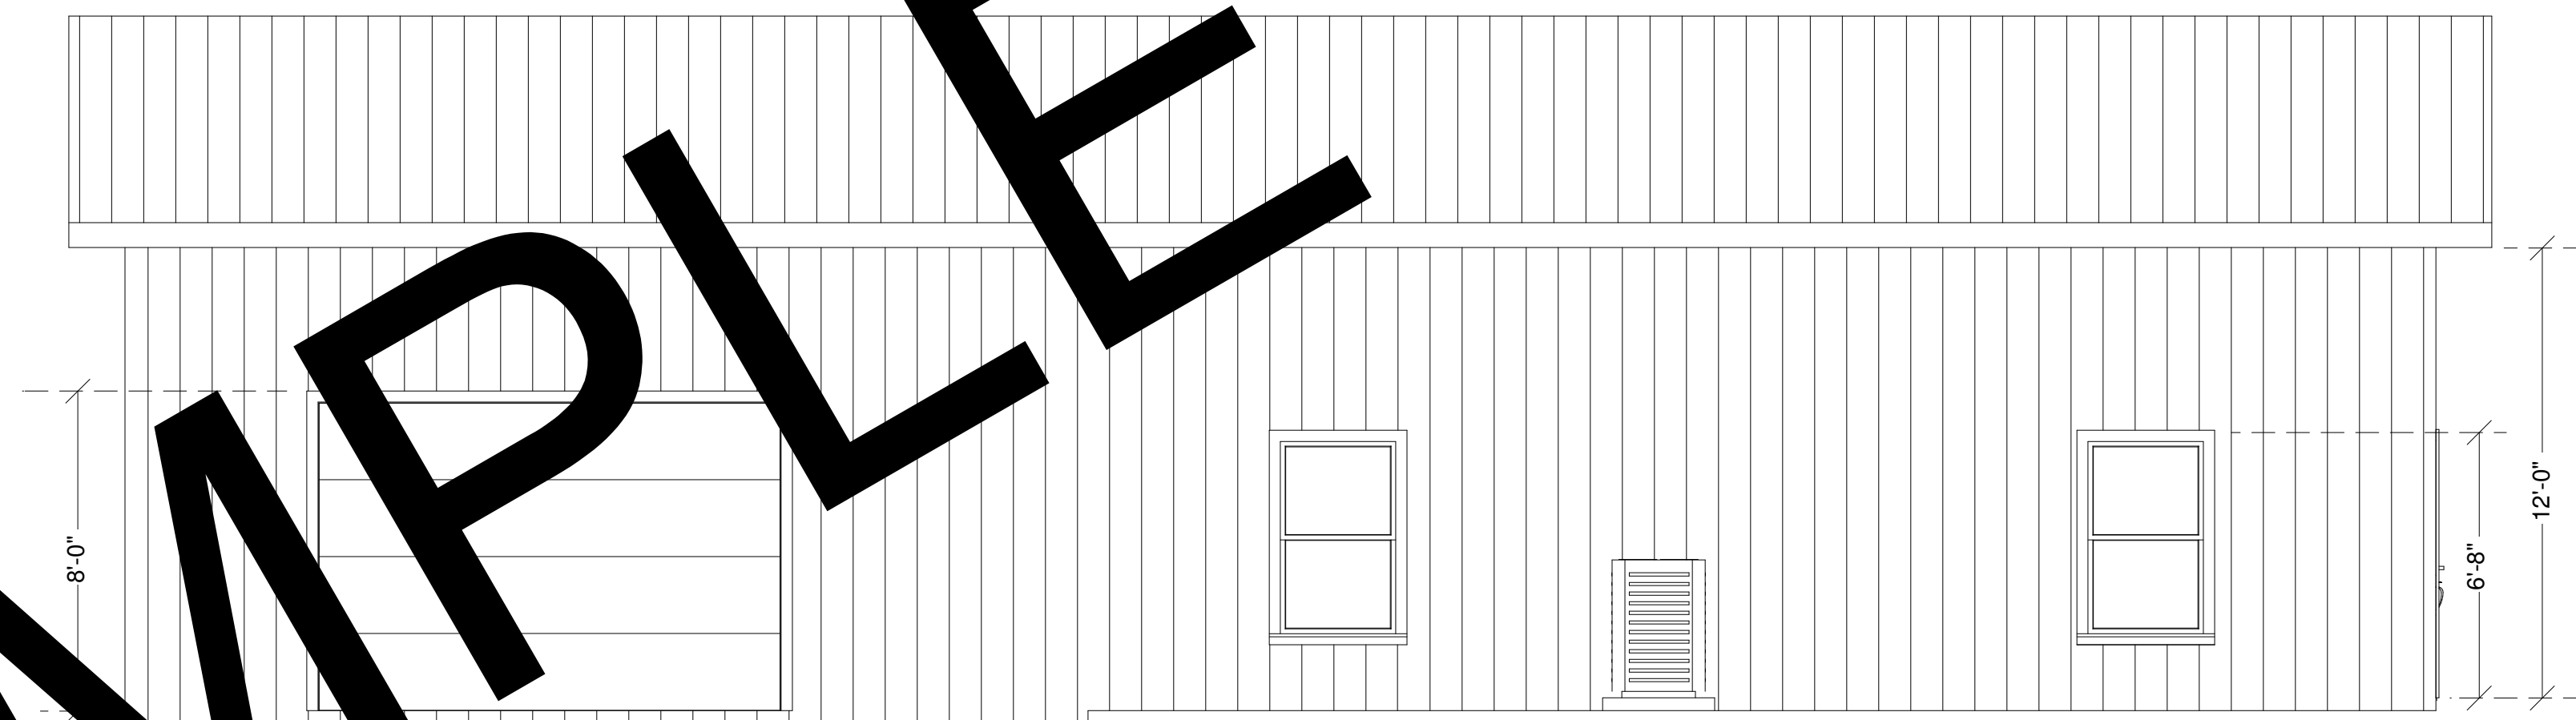

LEFT ELEVATION
SCALE: 1/4" = 1'-0"

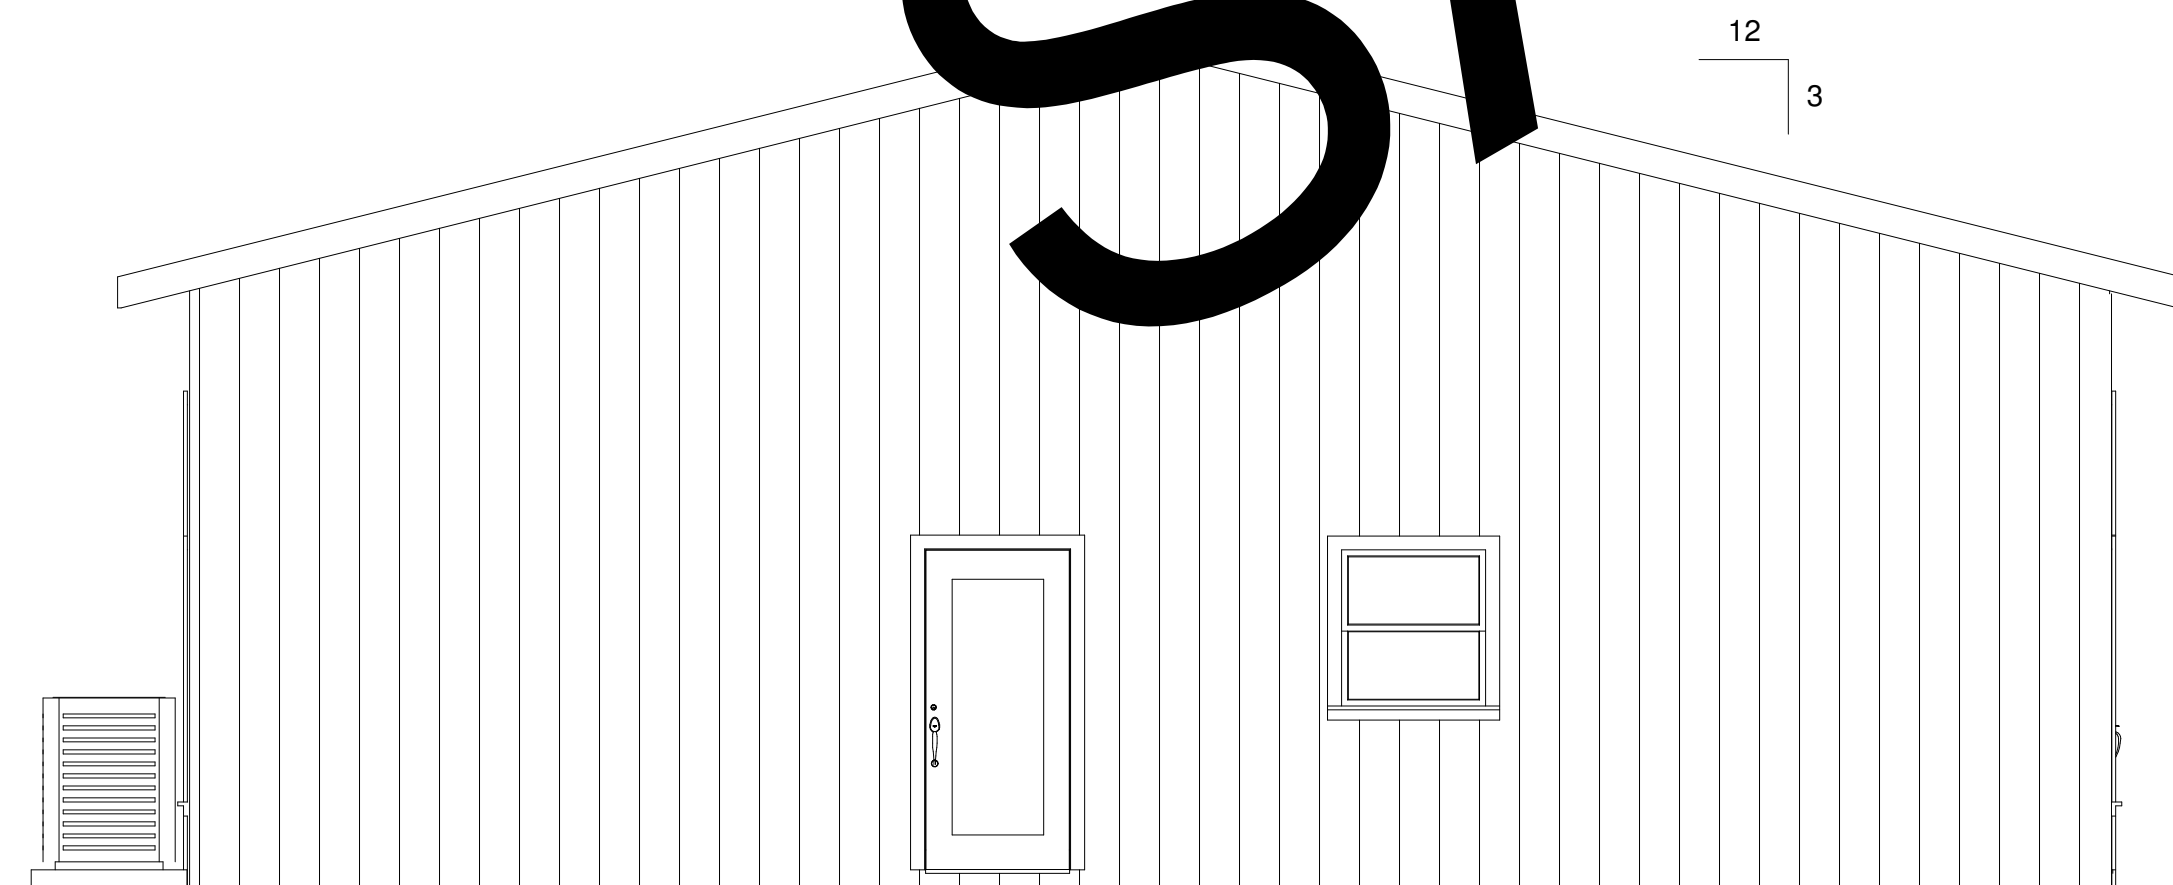

FRONT ELEVATION
SCALE: 1/4" = 1'-0"

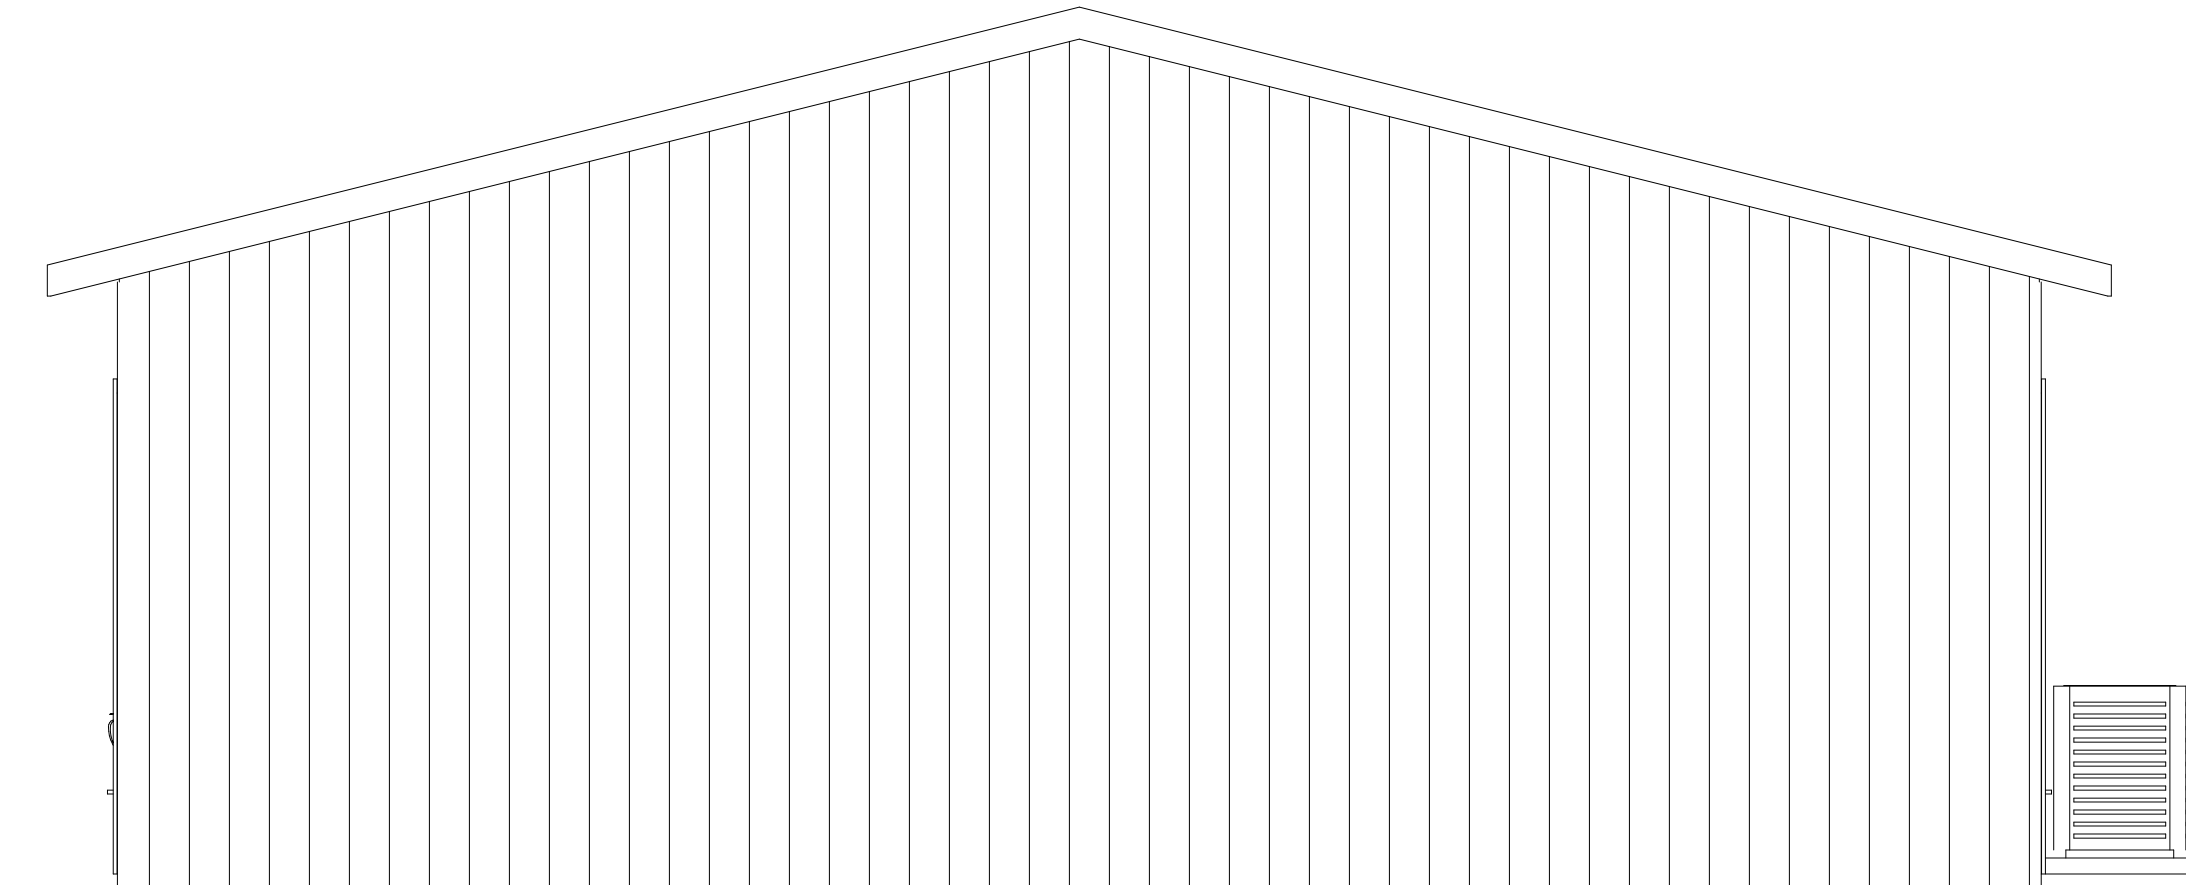




REAR ELEVATION
SCALE: 1/4" = 1'-0"

SAMPLE

THIS DESIGN IS THE INTELLECTUAL PROPERTY OF DREAMCATCHER BUILDING DESIGNS AND IS NOT TO BE USED OR REPRODUCED WITHOUT THE EXPRESS WRITTEN CONSENT OF DREAMCATCHER BUILDING DESIGNS.

NEW HOME SAMPLE PLAN #1


Dreamcatcher Building Designs (941) 462-0110 www.DreamcatcherBuildingDesigns.com

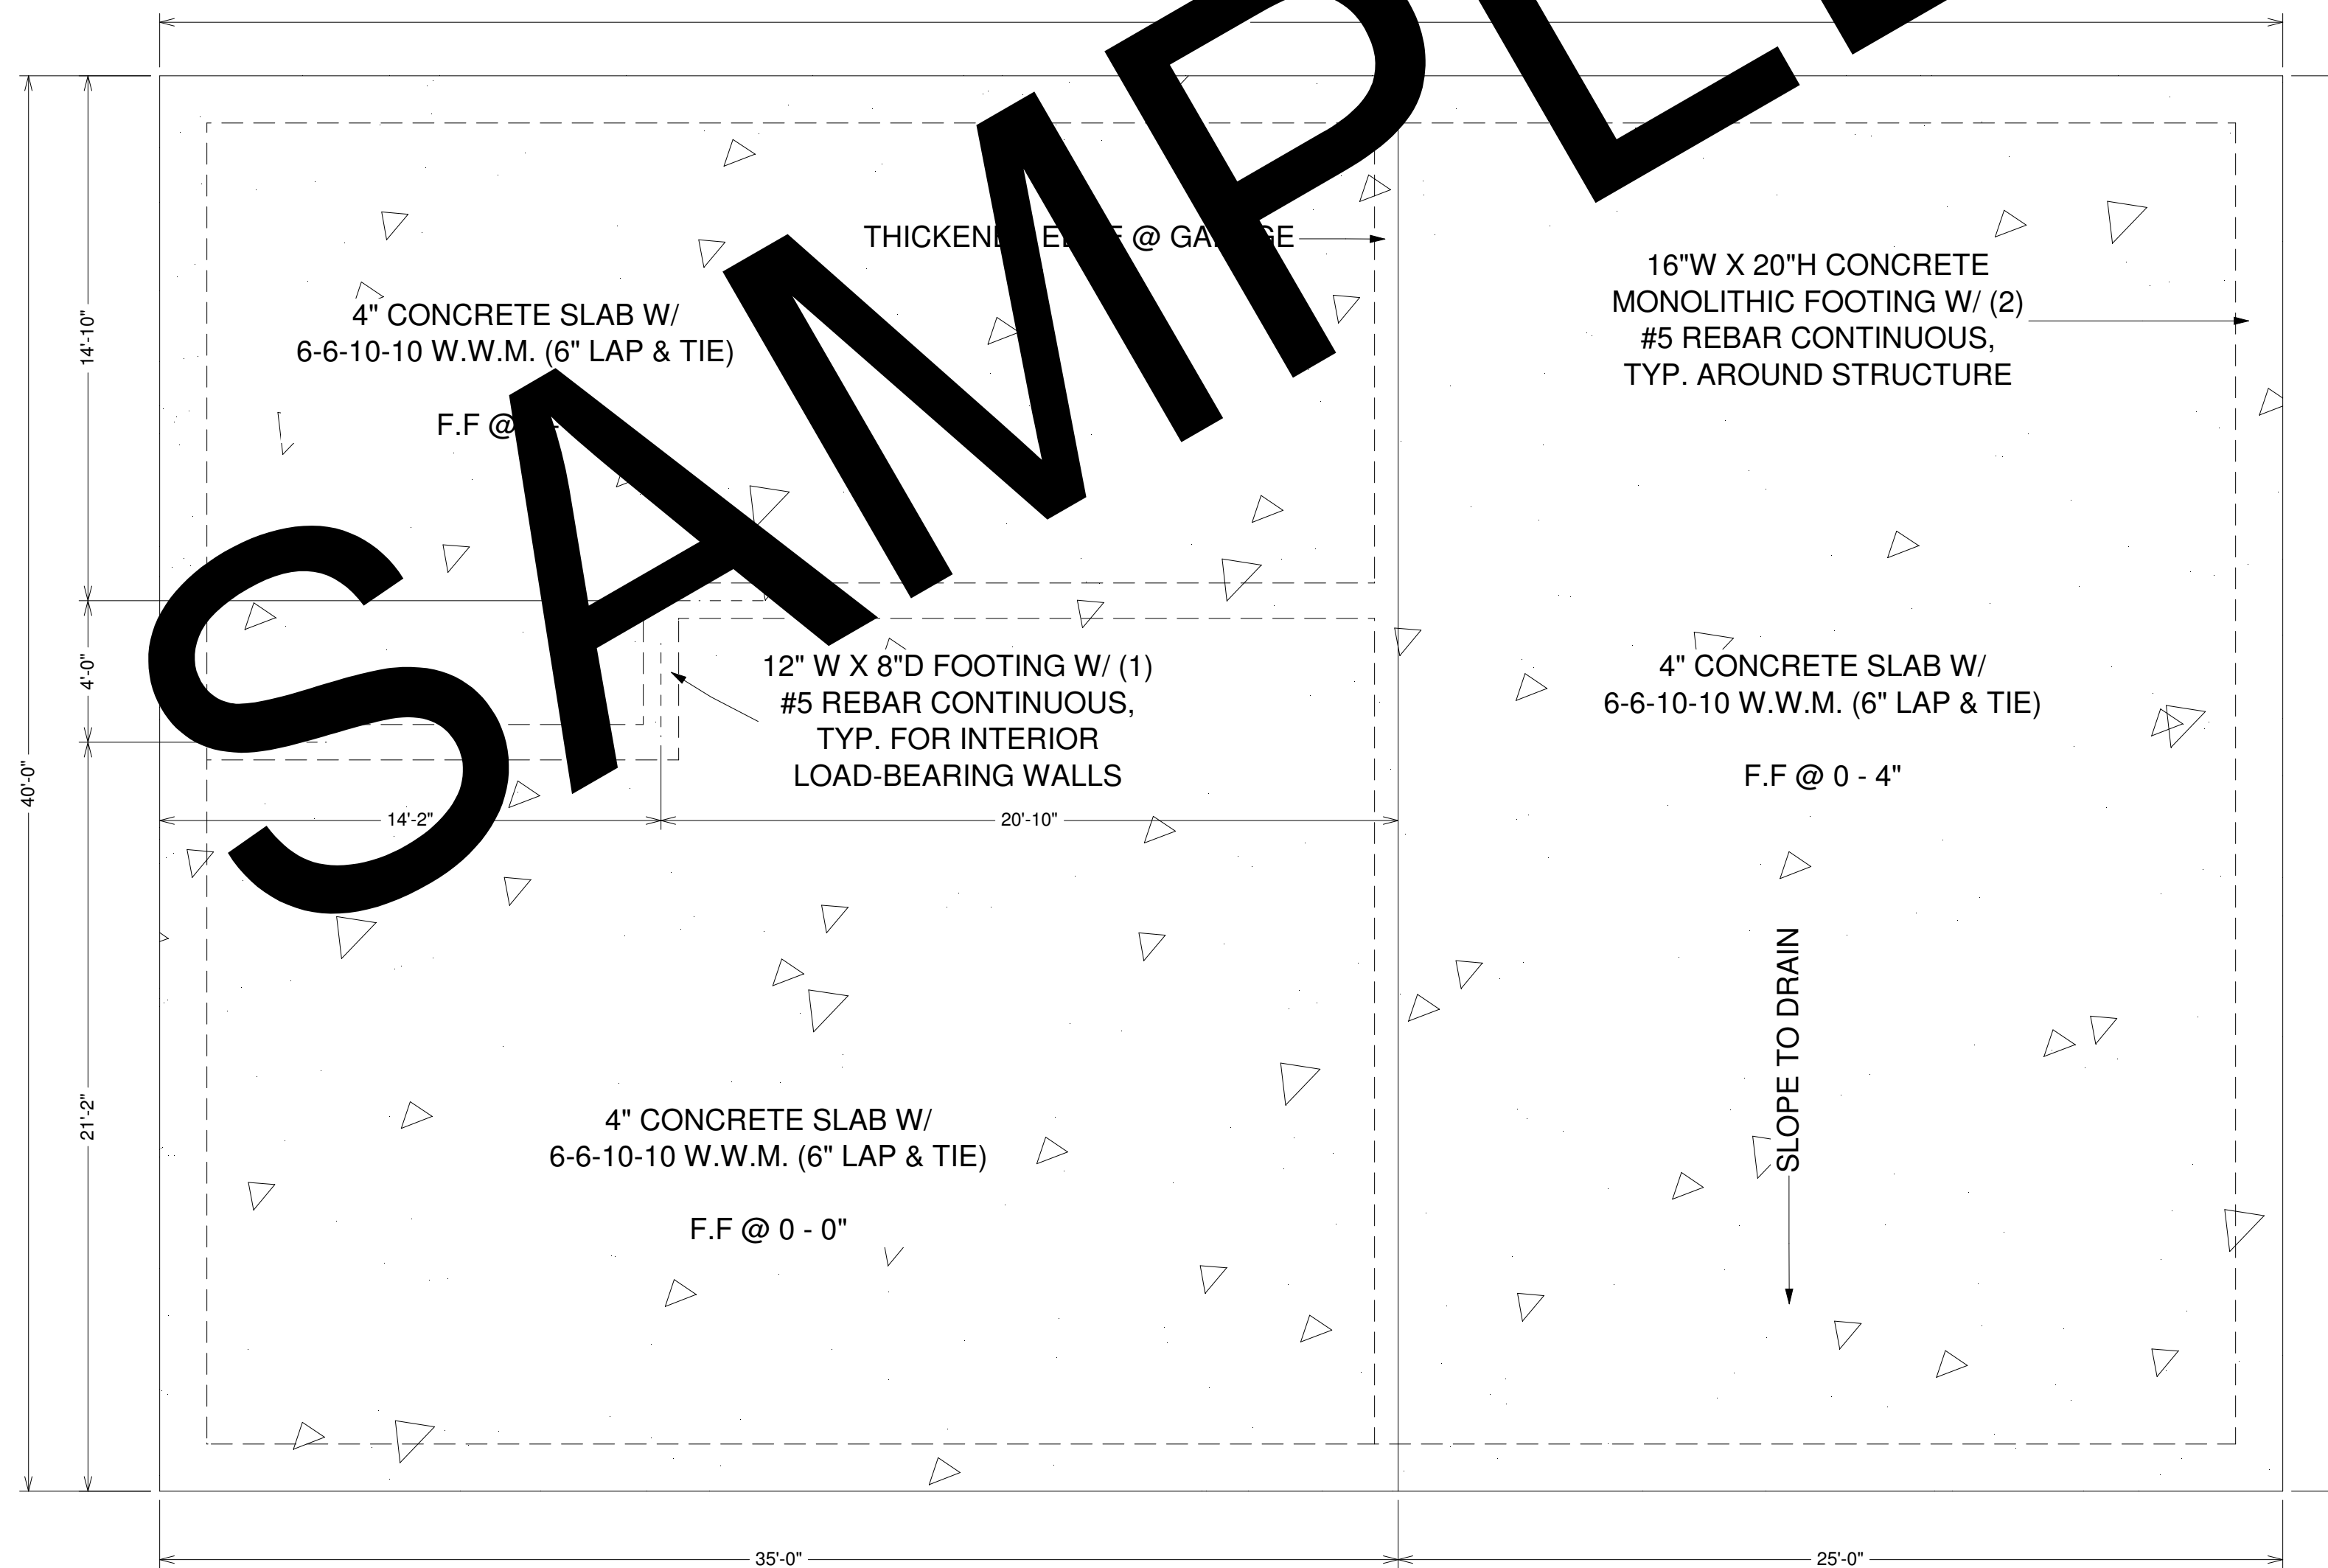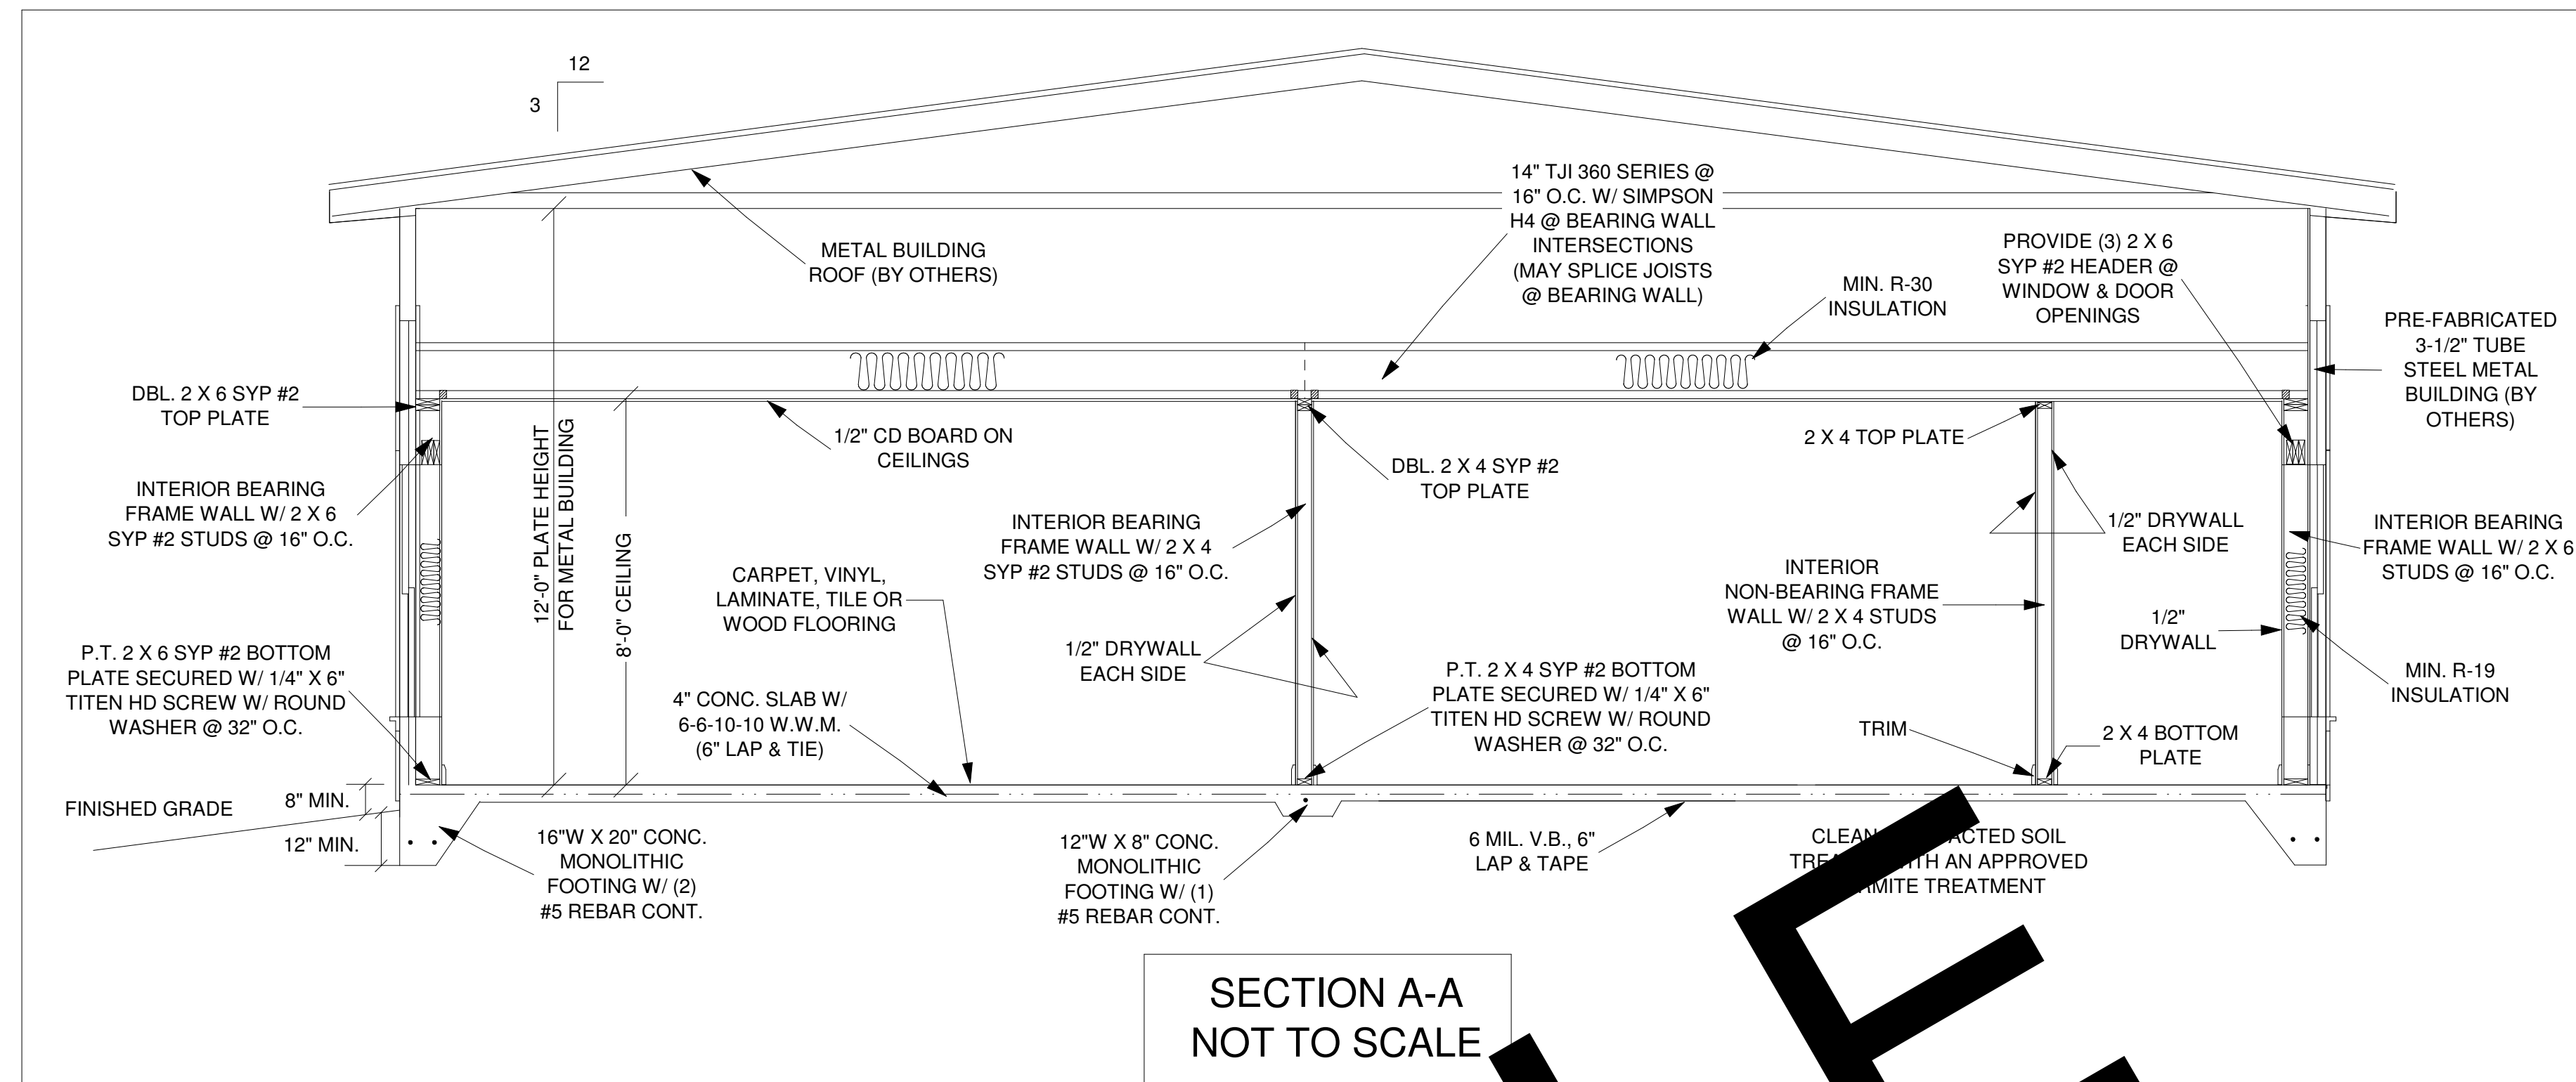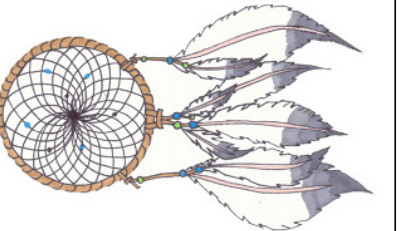


THIS DESIGN IS THE INTELLECTUAL PROPERTY OF DREAMCATCHER BUILDING DESIGNS AND IS NOT TO BE USED OR REPRODUCED WITHOUT THE EXPRESS WRITTEN CONSENT OF DREAMCATCHER BUILDING DESIGNS.

NEW HOME SAMPLE
PLAN #1

Dreamcatcher
Building Designs
(941) 462-0110
www.DreamcatcherBuildingDesigns.com

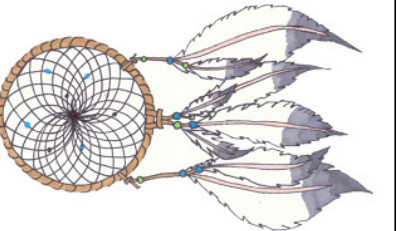


NOTE: THIS ROOF PLAN IS PROVIDED FOR REFERENCE PURPOSES ONLY. STRUCTURAL DESIGN IS THE RESPONSIBILITY OF THE METAL BUILDING FABRICATOR/INSTALLER. SEE METAL BUILDING PLANS BY OTHERS.

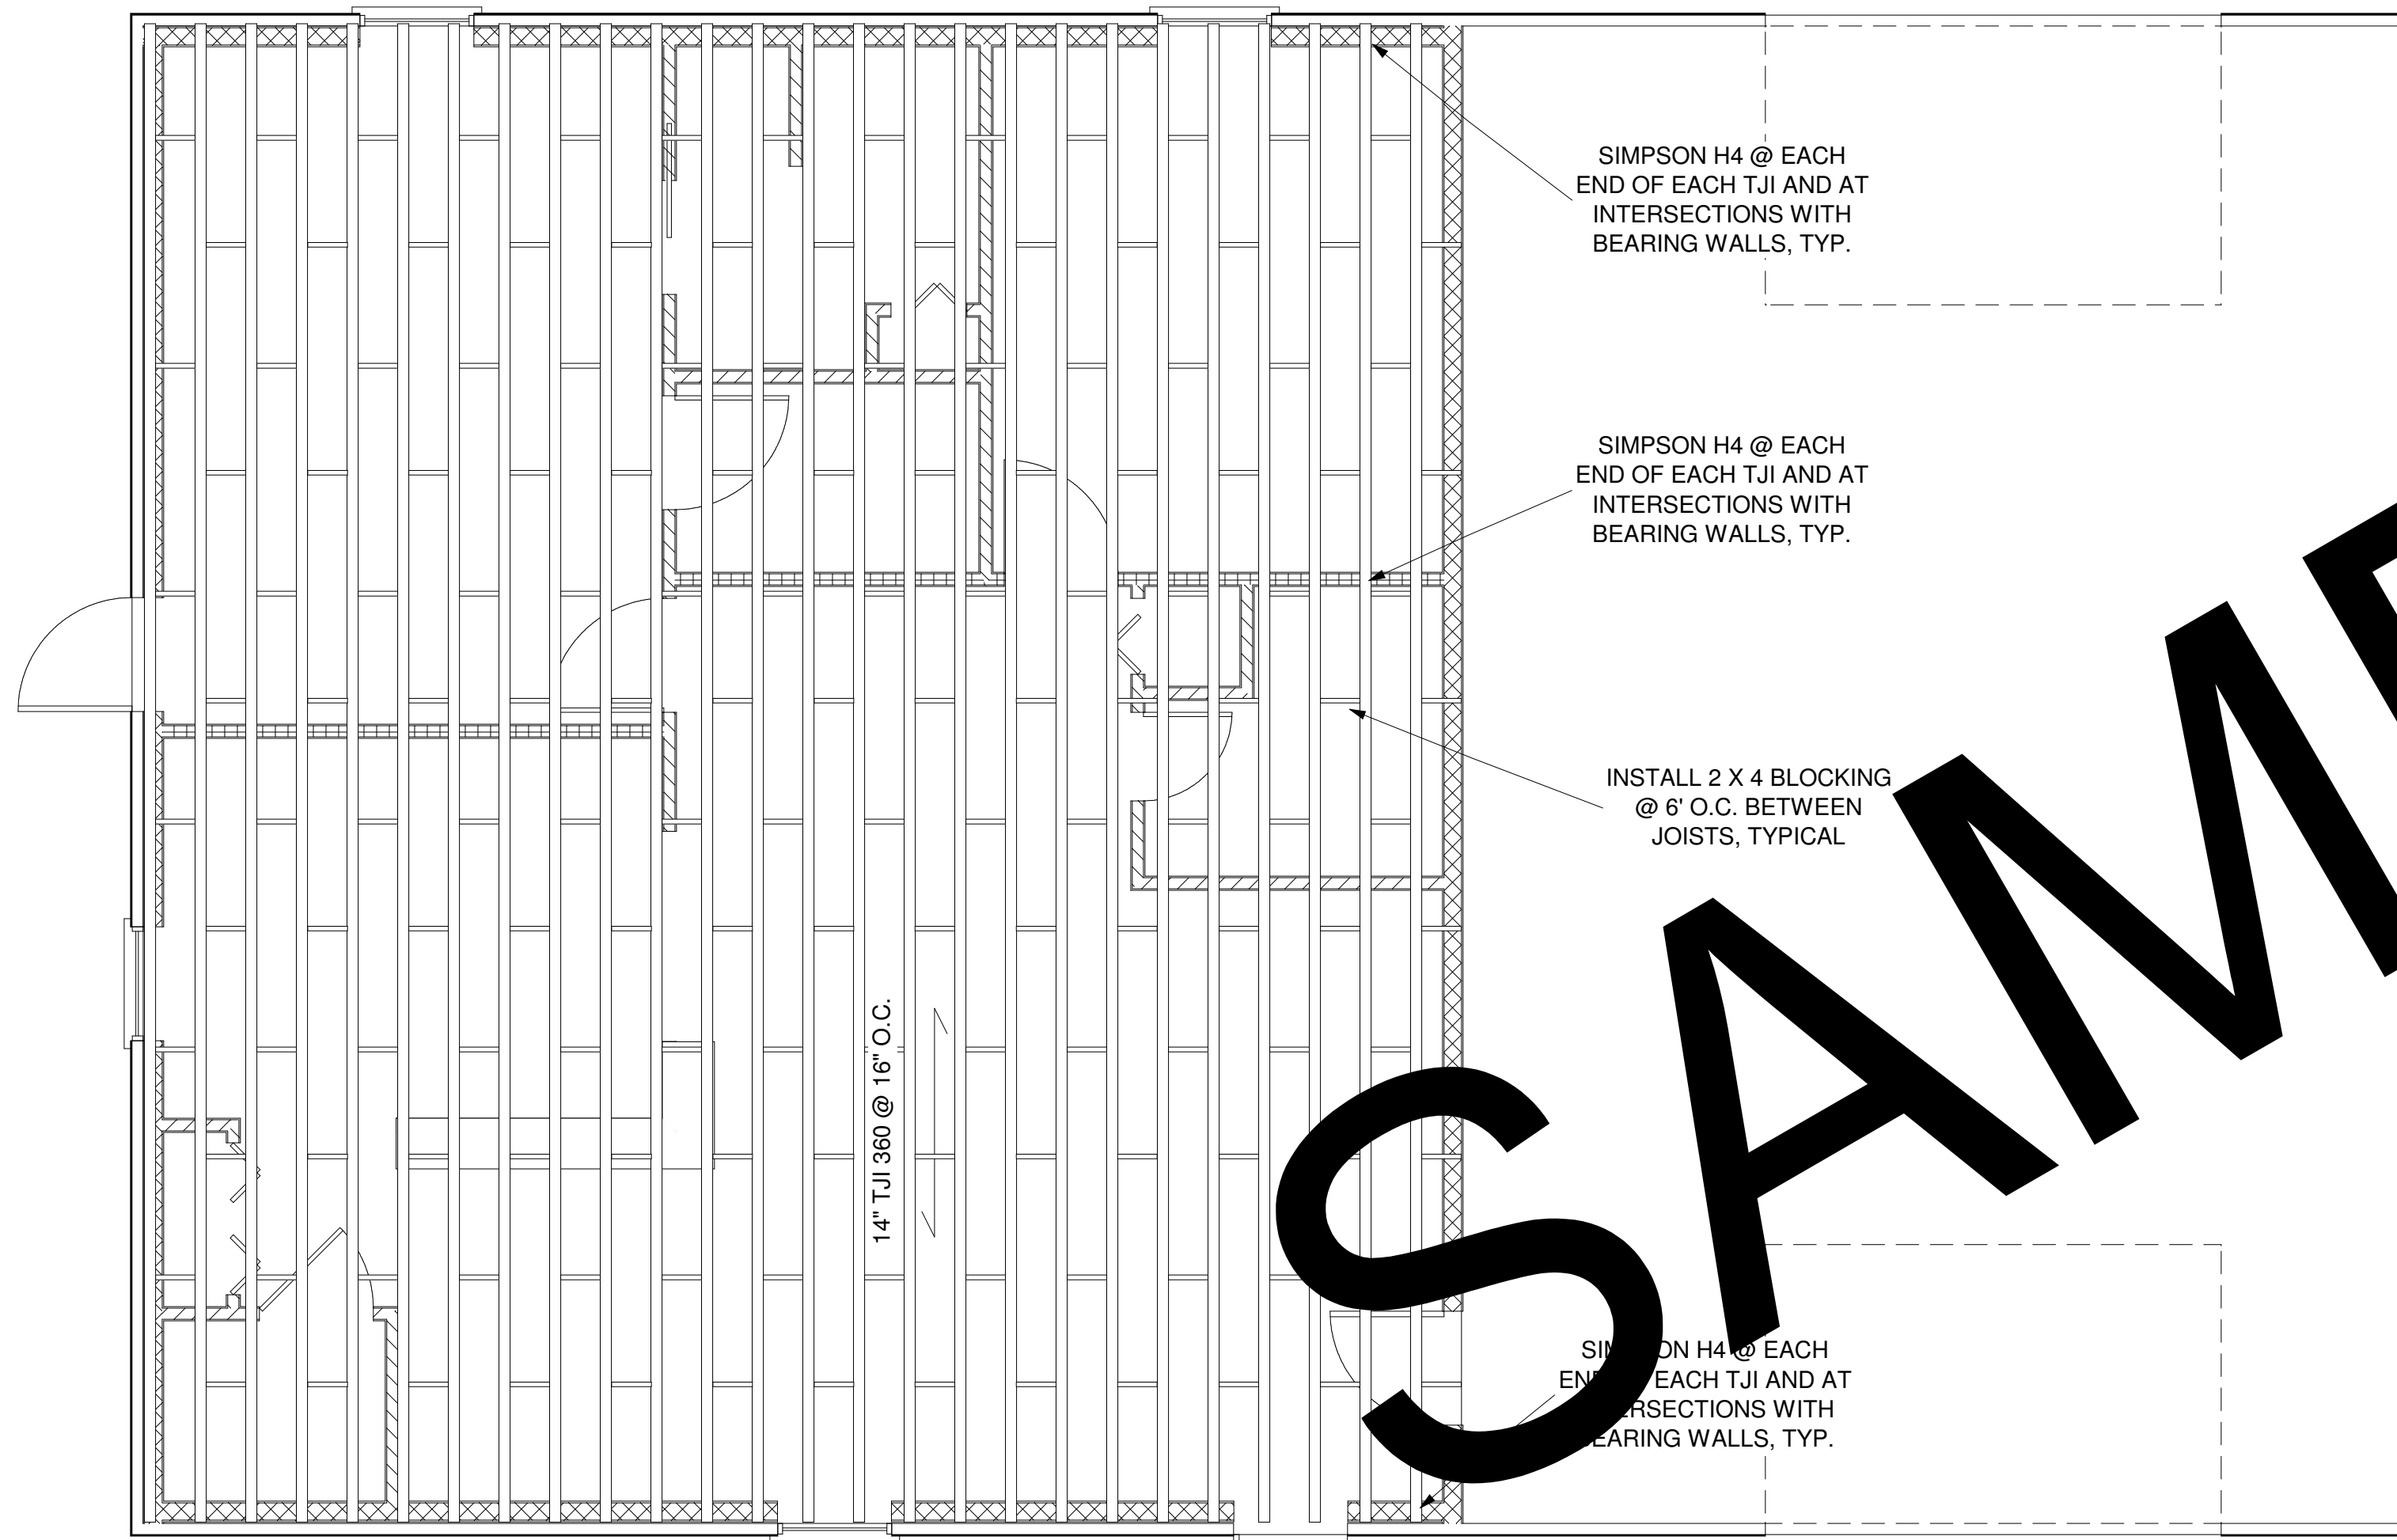

CEILING FRAMING PLAN
SCALE: 1/4" = 1'-0"

NOTE: TJI'S MAY BE SPLICED AT BEARING WALL LOCATIONS.

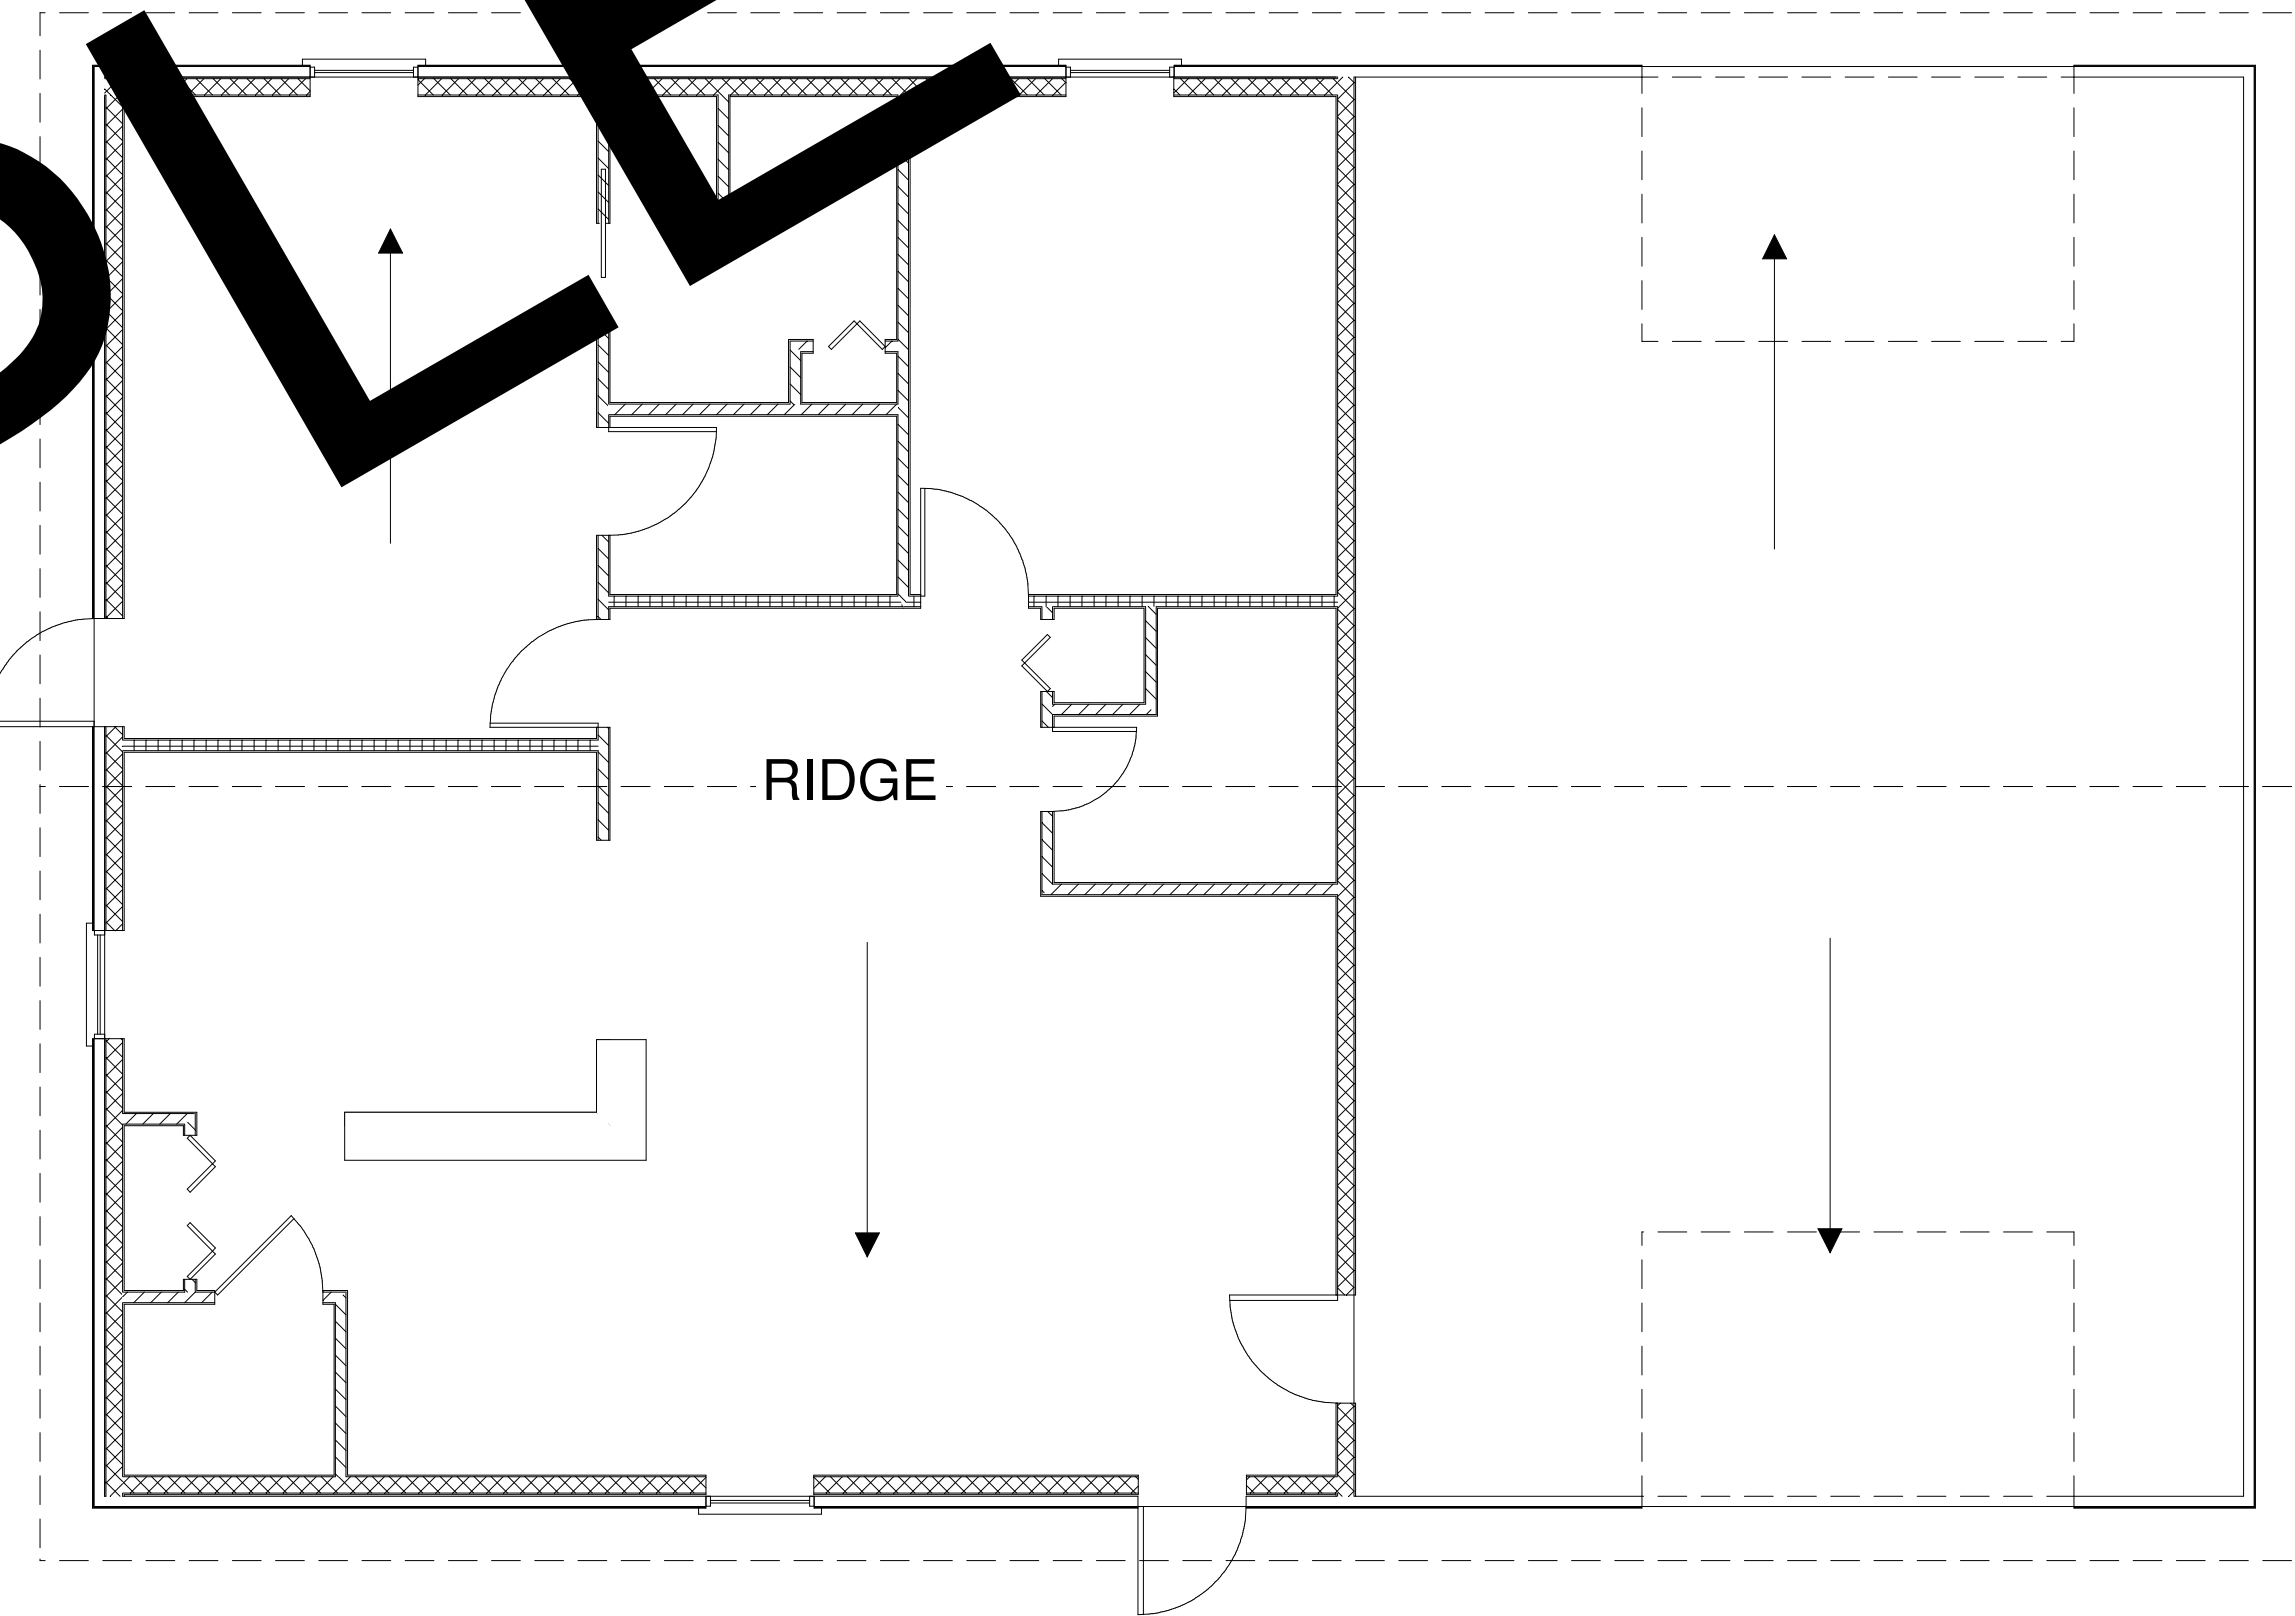

ROOF PLAN
SCALE: 3/16" = 1'-0"

SAMPLE