
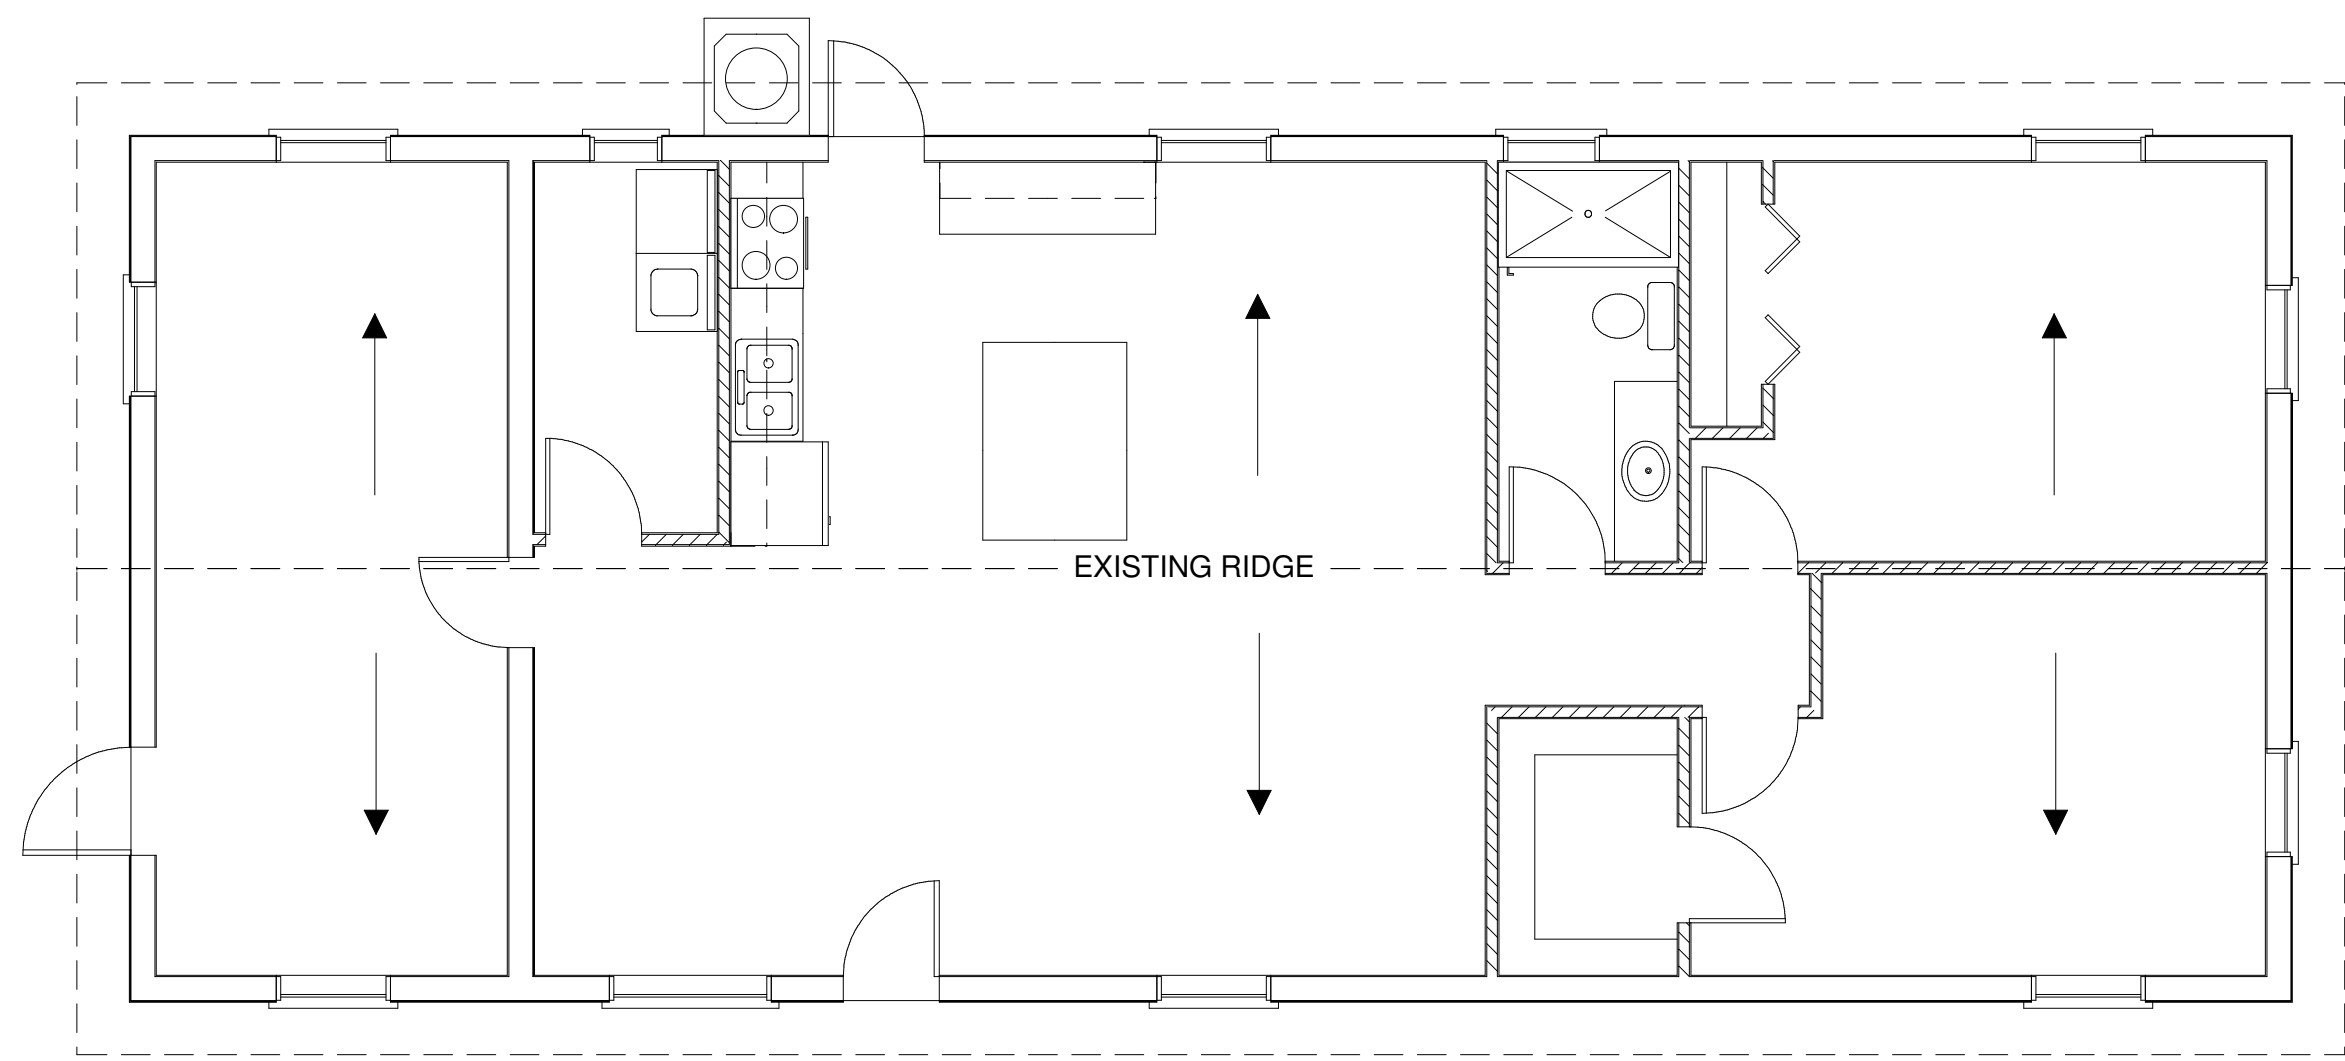


THIS DESIGN IS THE INTELLECTUAL PROPERTY OF DREAMCATCHER BUILDING DESIGNS. IT IS NOT TO BE REPRODUCED OR REUSED WITHOUT THE EXPRESS CONSENT OF DREAMCATCHER BUILDING DESIGNS.

SAMPLE DUPLEX TO SINGLE FAMILY CONVERSION PALMETTO, FLORIDA


Dreamcatcher Building Designs (941) 462-0110 www.DreamcatcherBuildingDesigns.com

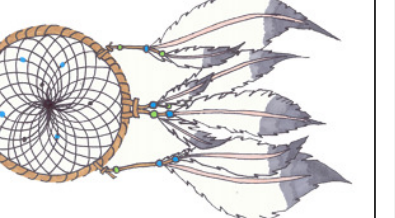

ROOF PLAN SCALE: 3/16" = 1'-0"


NOTE:

EXISTING ROOF SYSTEM TO REMAIN. REMOVE AND REPLACE ROTTED WOOD FASCIA AS REQUIRED. INSTALL NEW ALUMINUM OR VINYL SOFFIT & FASCIA.

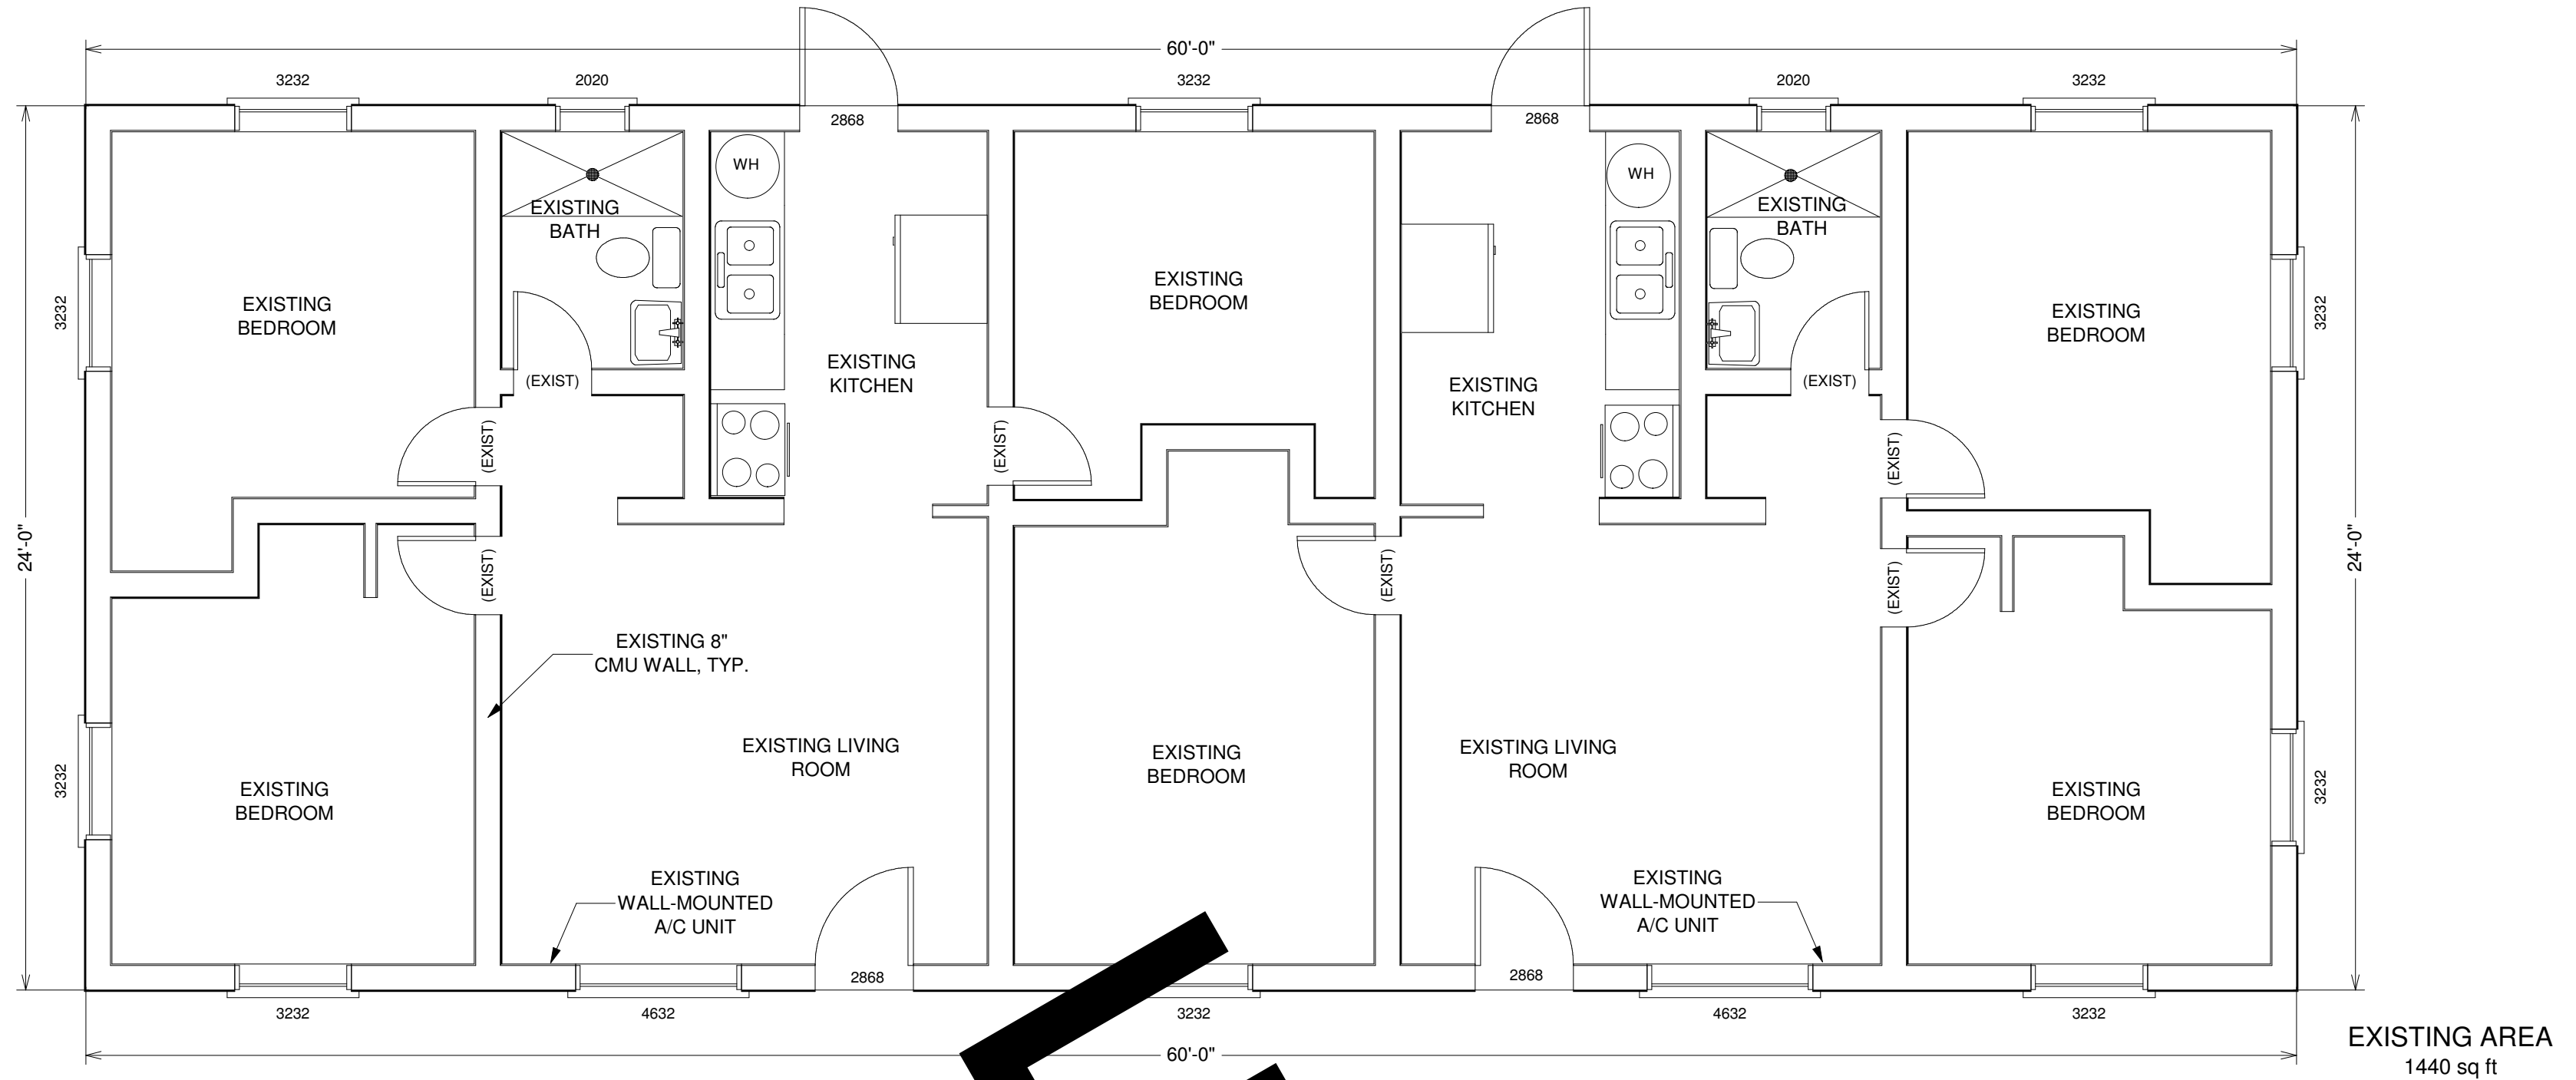

EXISTING FLOOR PLAN SCALE: 1/4" = 1'-0"

EXISTING AREA 1440 sq ft

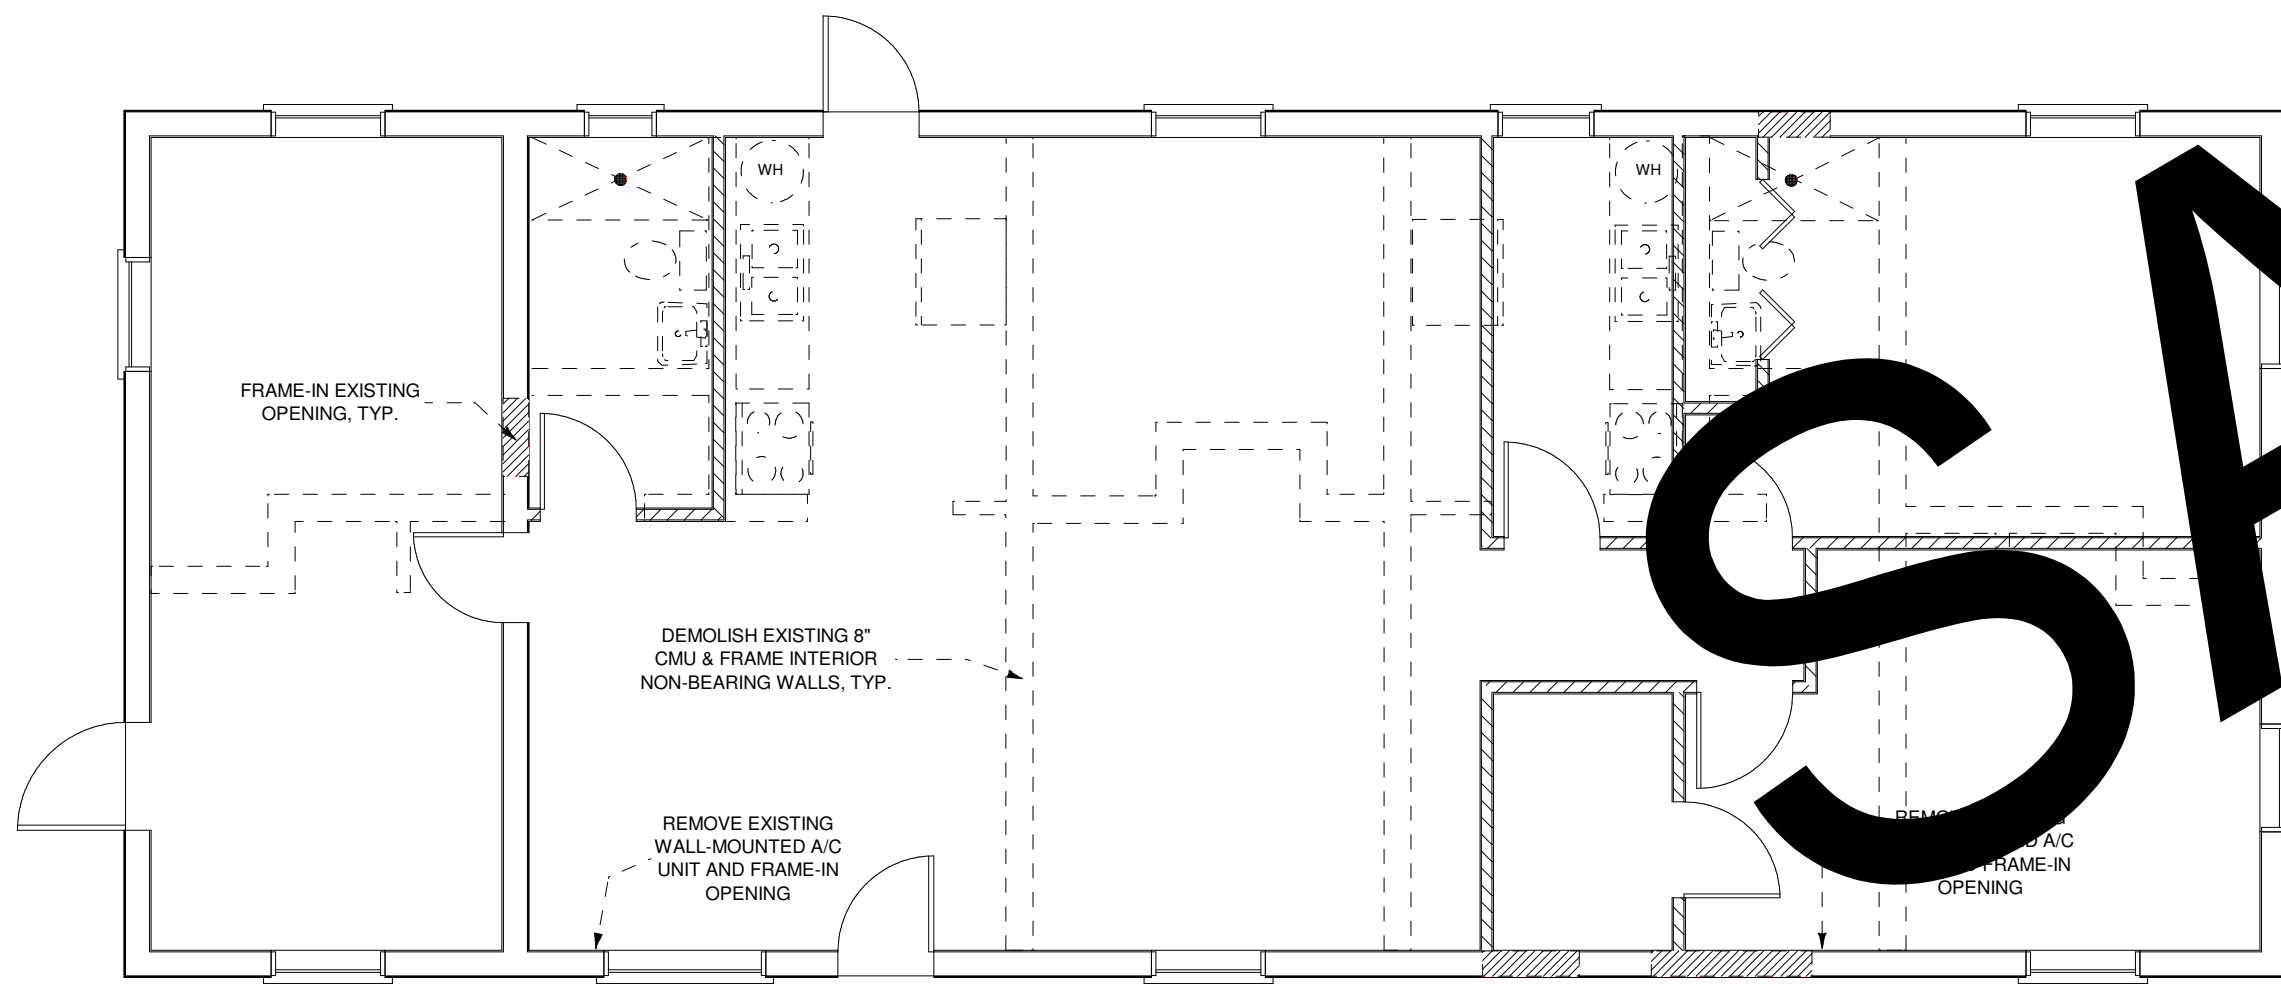

DEMOLITION PLAN SCALE: 3/16" = 1'-0"


NOTE:

REMOVE EXISTING INTERIOR WALLS, APPLIANCES, AND PLUMBING FIXTURES AS INDICATED.

NOTE:


REMOVE AND REPLACE ALL EXTERIOR DOORS AND WINDOWS WITH SAME SIZE UNLESS OTHERWISE NOTED.

ALL ELECTRICAL SHOWN IS NEW.

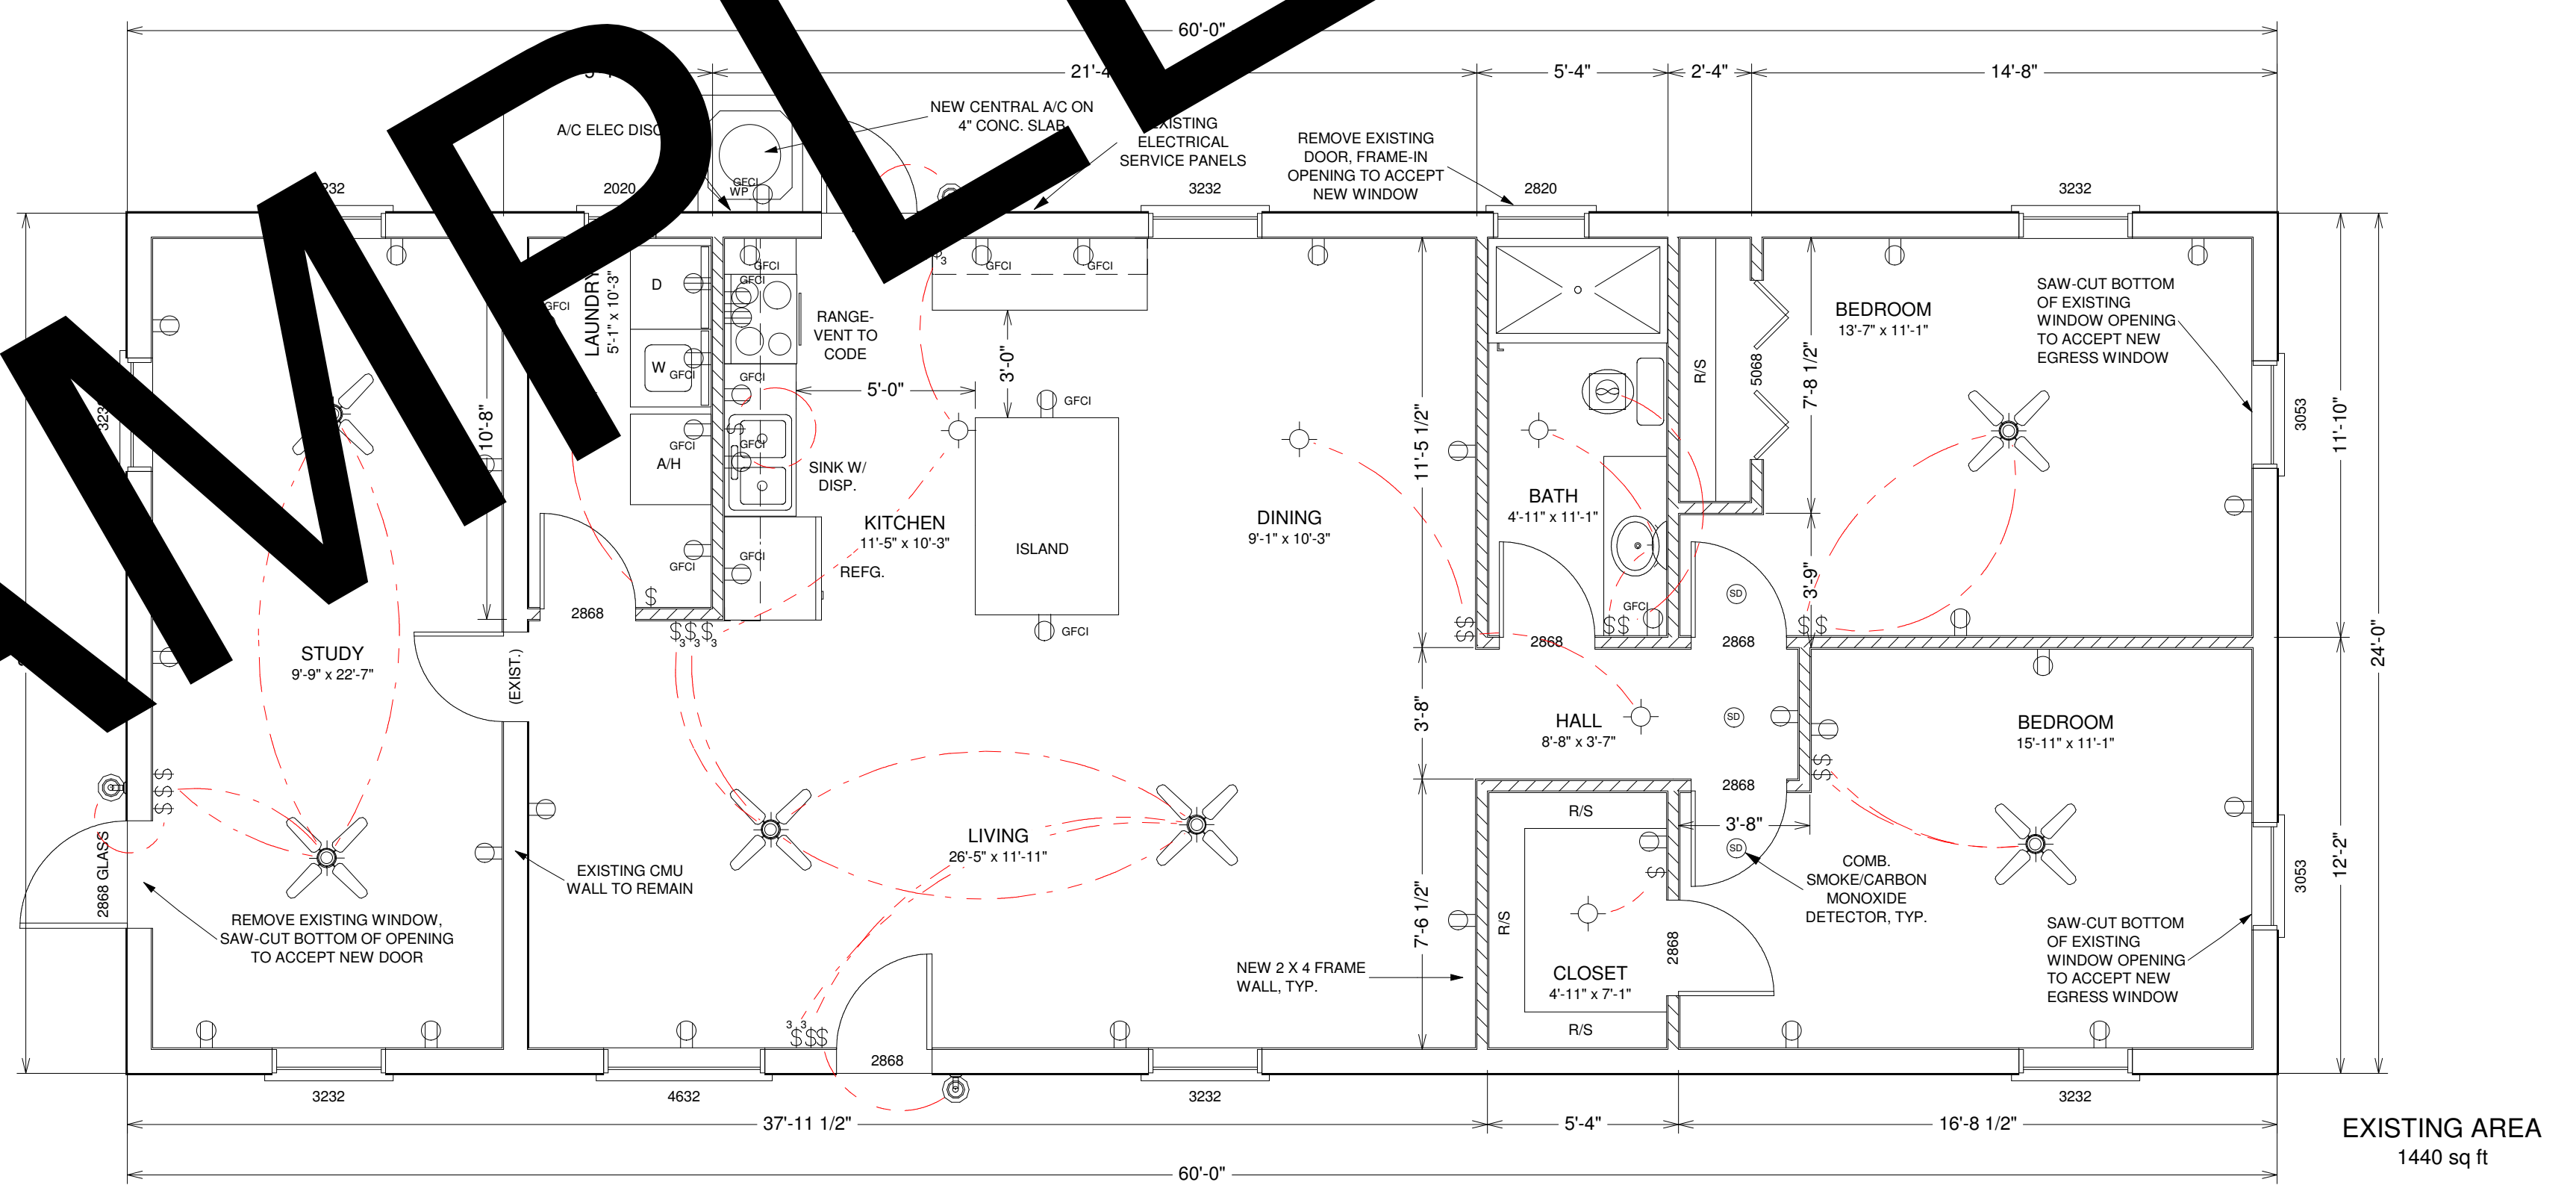


PROPOSED FLOOR & ELECTRICAL PLAN SCALE: 1/4" = 1'-0"


EXISTING AREA 1440 sq ft

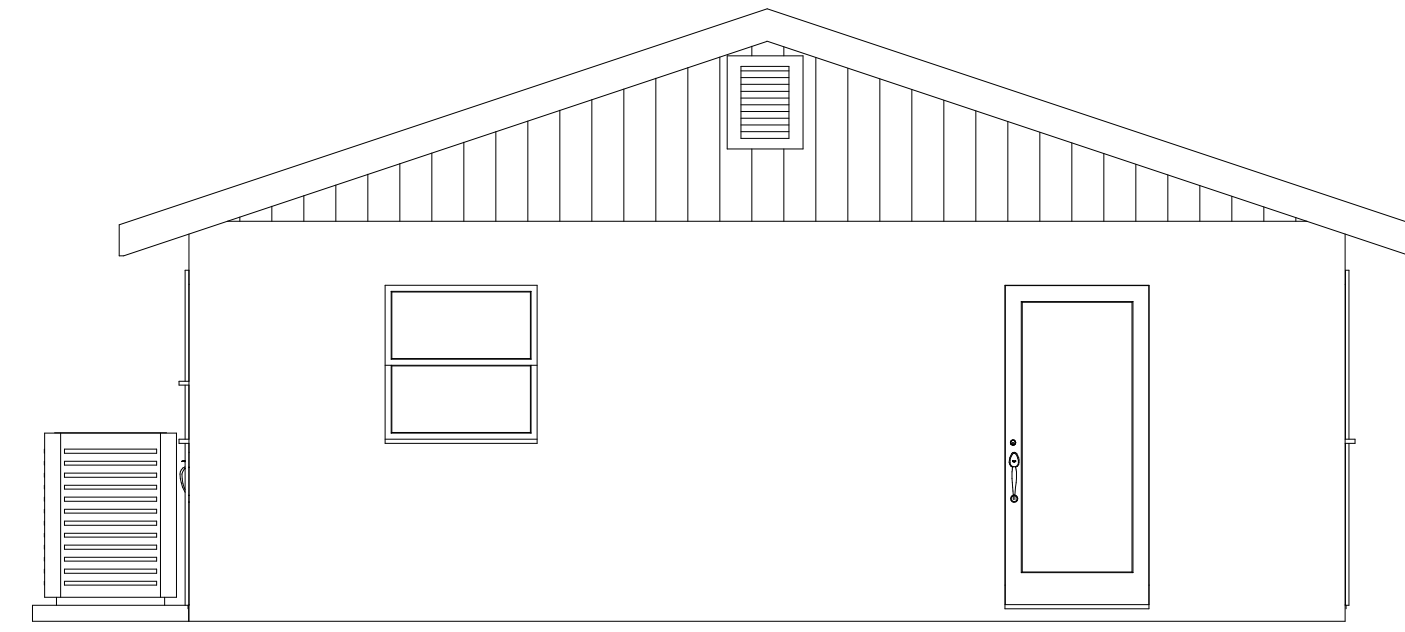


FRONT ELEVATION
SCALE: 1/4" = 1'-0"

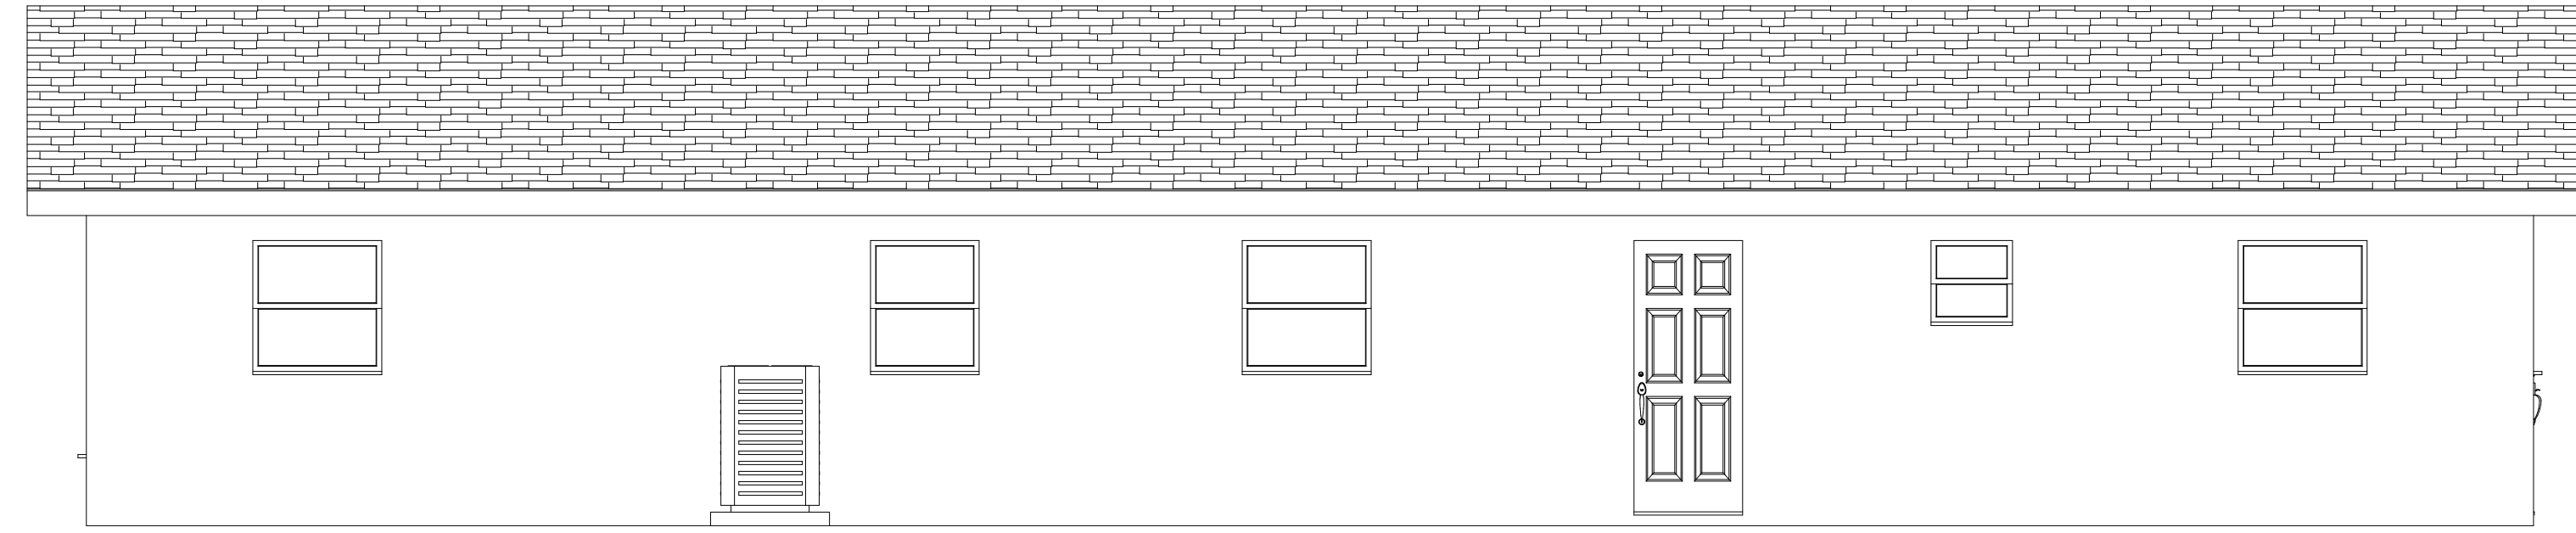

LEFT ELEVATION
SCALE: 1/4" = 1'-0"

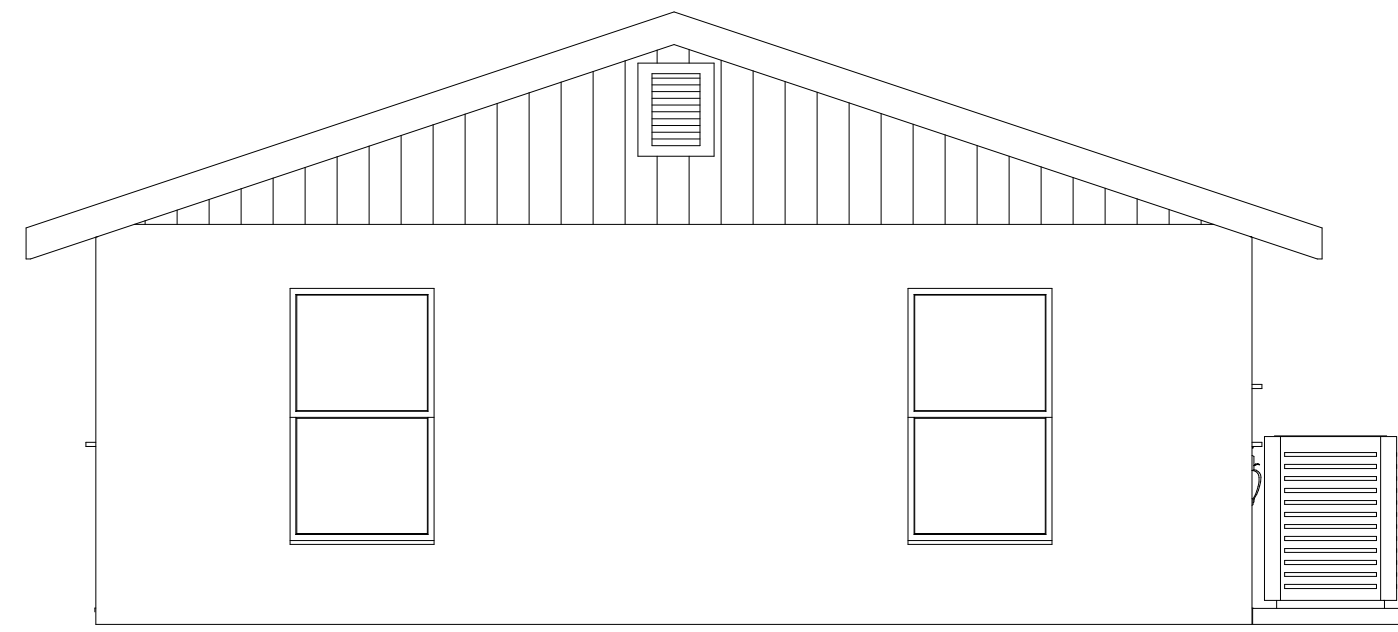

REAR ELEVATION
SCALE: 1/4" = 1'-0"

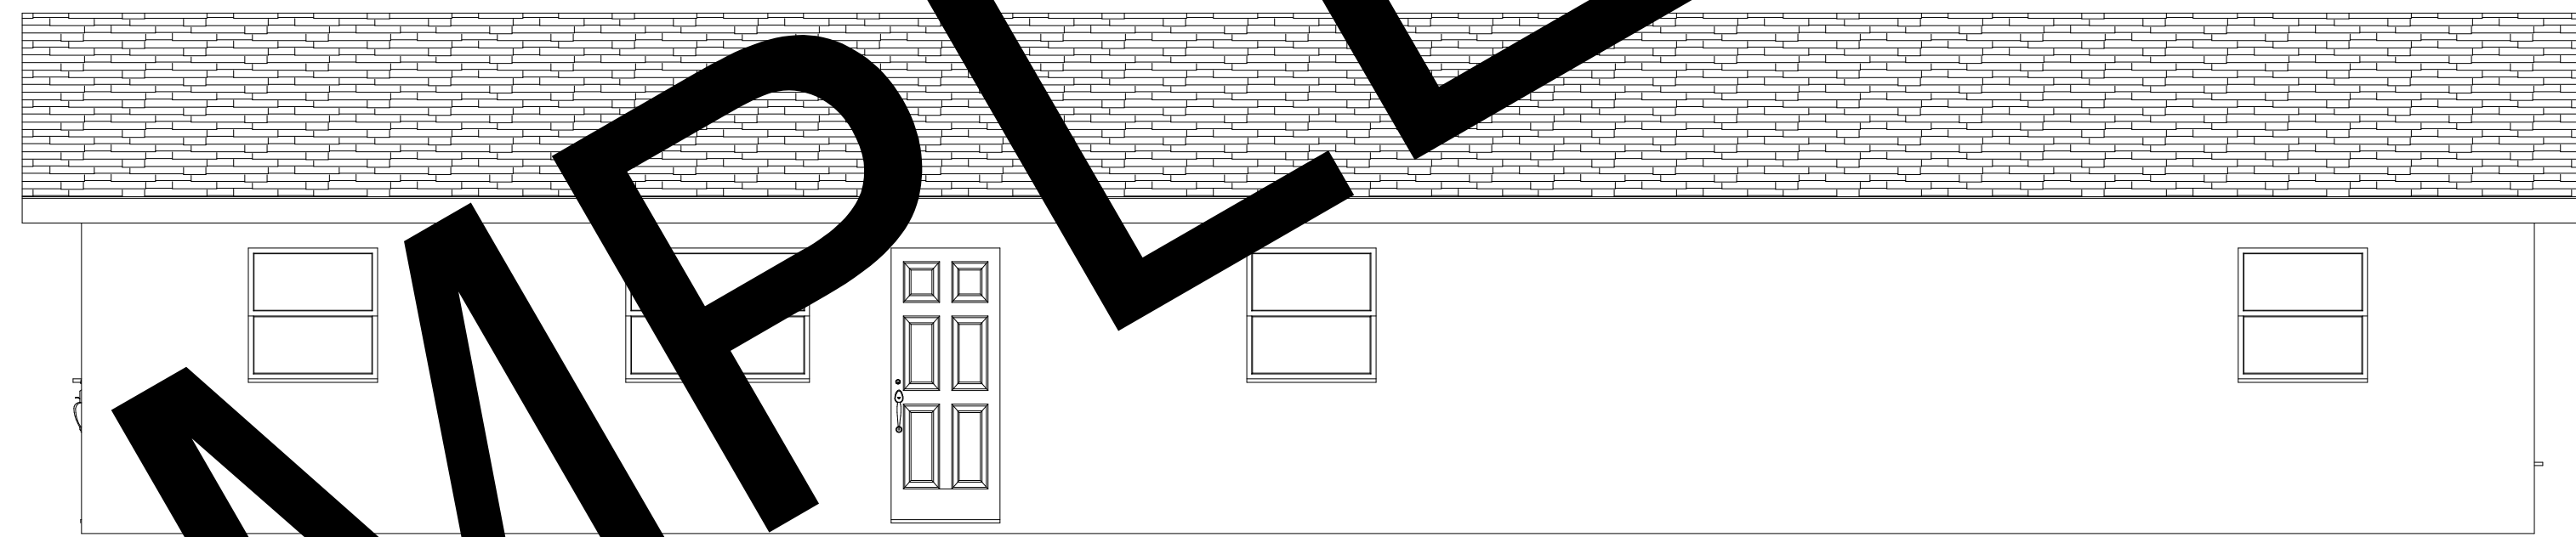

RIGHT ELEVATION
SCALE: 1/4" = 1'-0"

SAMPLE

THIS DESIGN IS THE INTELLECTUAL
PROPERTY OF DREAMCATCHER
BUILDING DESIGNS. IT IS NOT TO BE
REPRODUCED OR REUSED WITHOUT
THE EXPRESS CONSENT OF
DREAMCATCHER BUILDING DESIGNS.

SAMPLE DUPLEX TO SINGLE
FAMILY CONVERSION
PALMETTO, FLORIDA

Dreamcatcher
Building Designs
(941) 462-0110
www.DreamcatcherBuildingDesigns.com

