
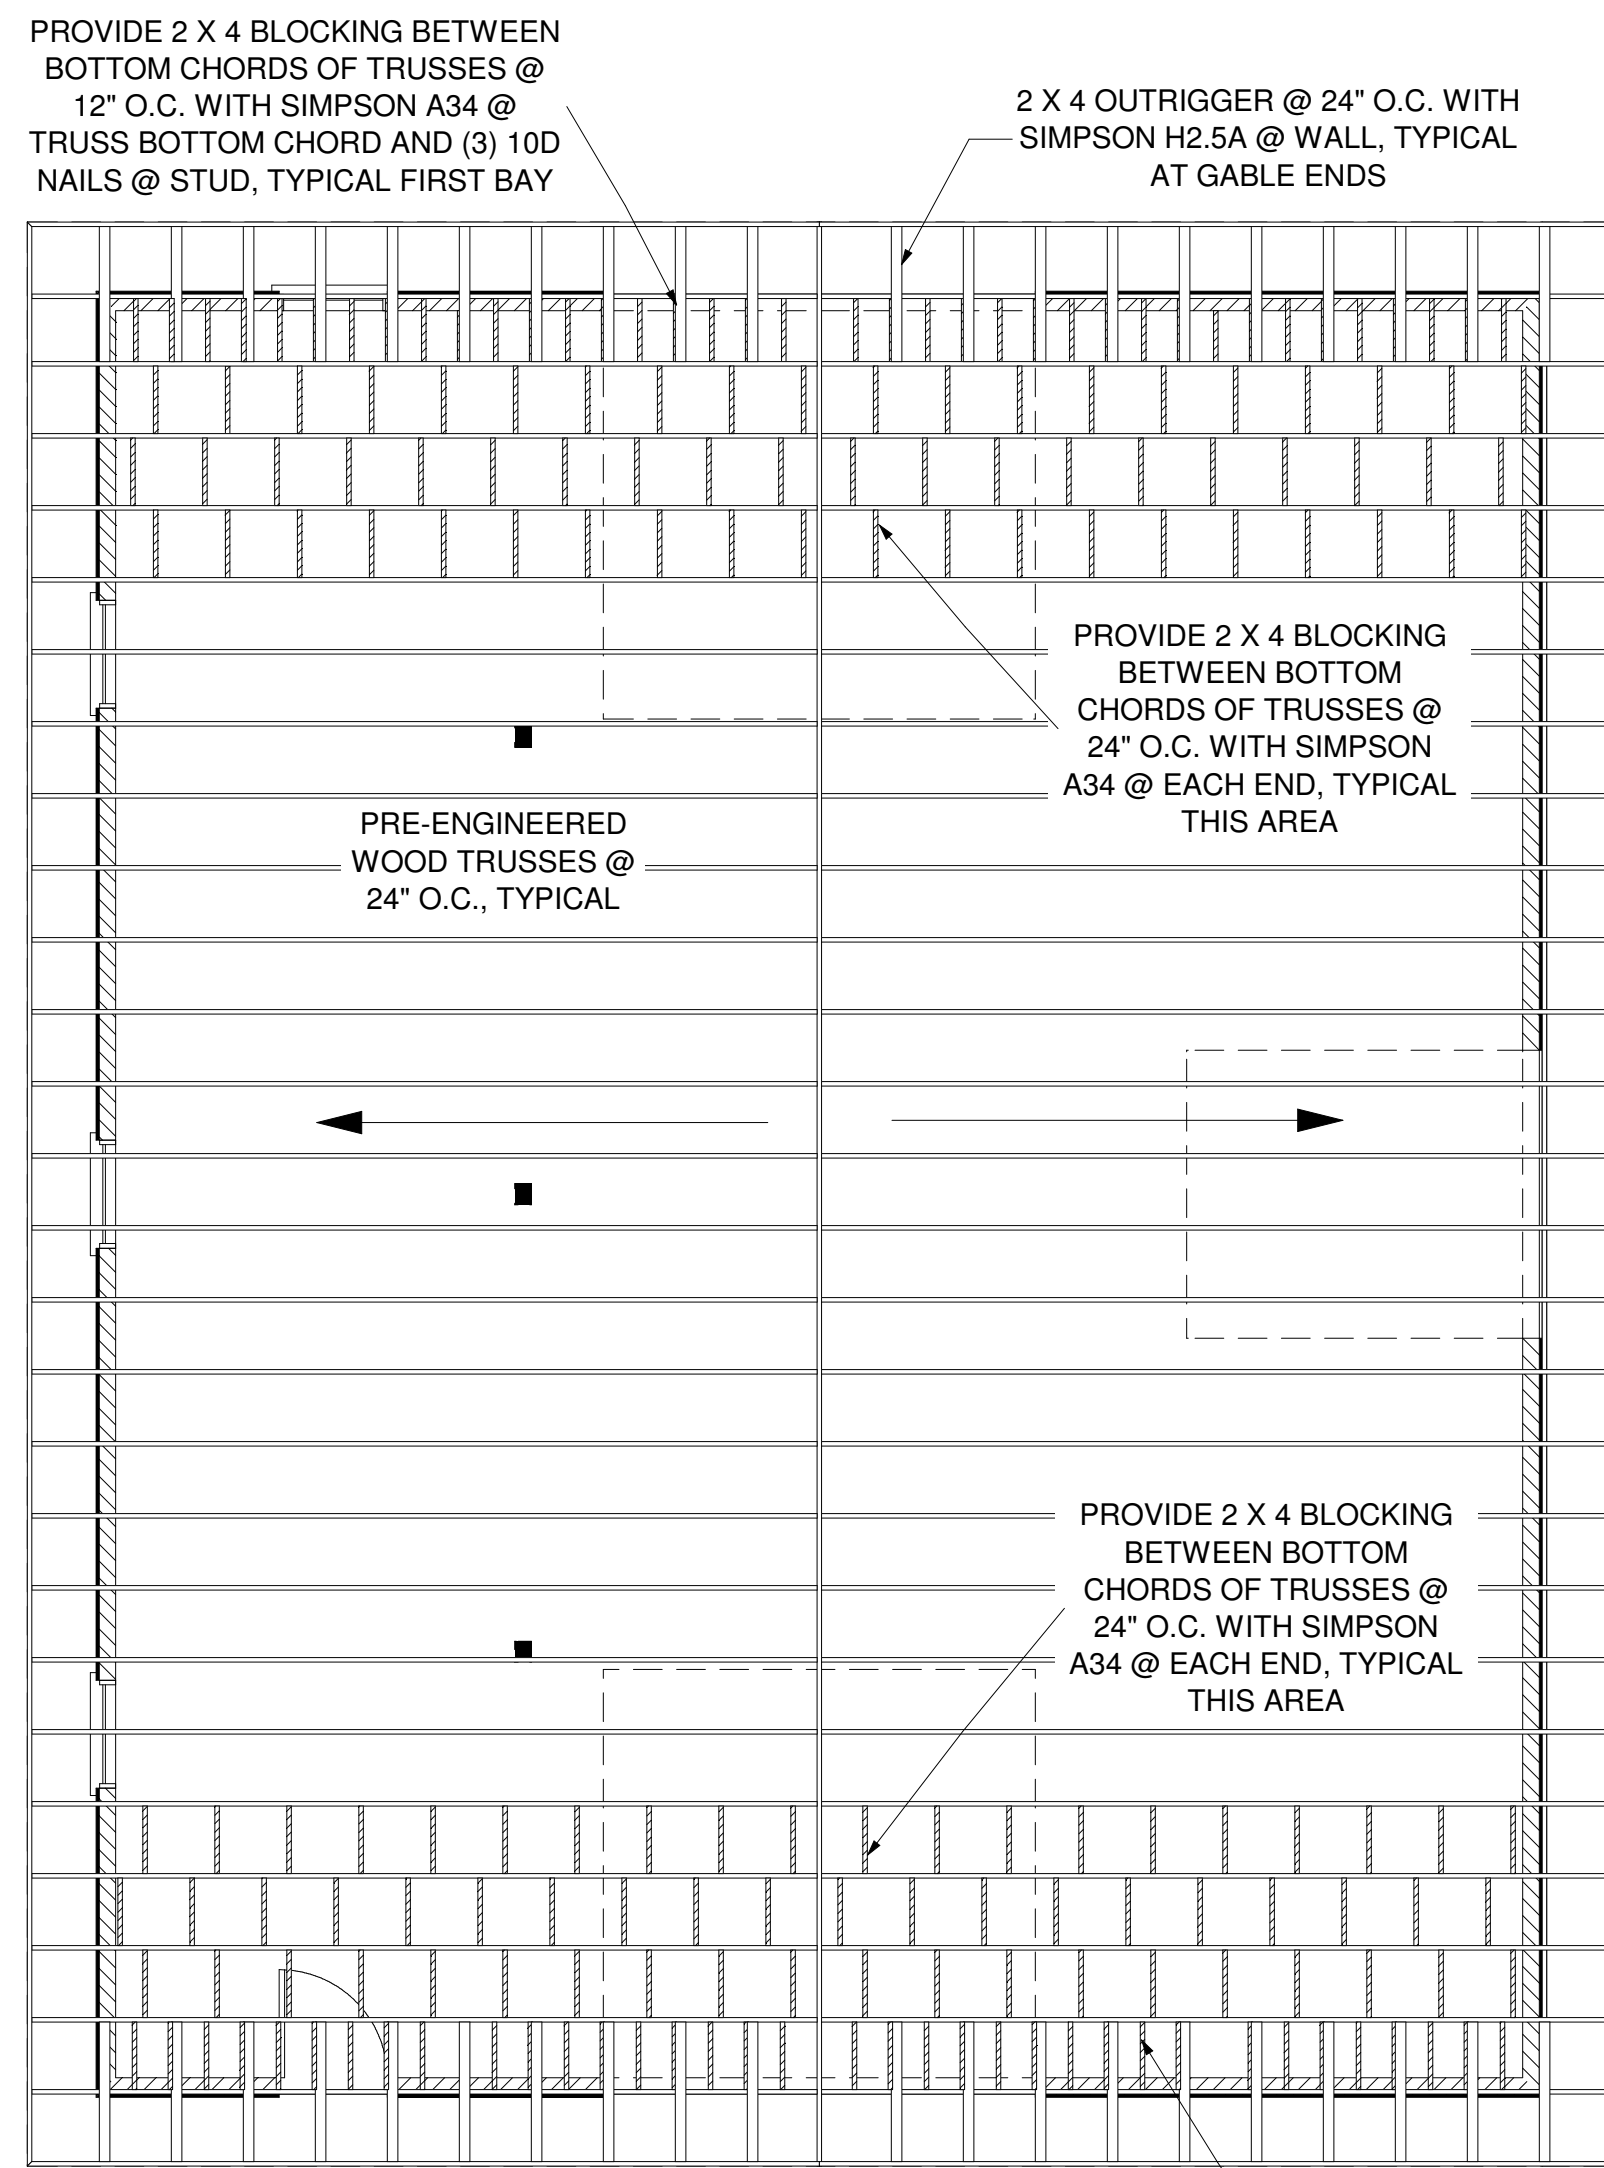


THIS DESIGN IS THE INTELLECTUAL PROPERTY OF DREAMCATCHER BUILDING DESIGNS. IT IS NOT TO BE REPRODUCED OR REUSED WITHOUT THE EXPRESS CONSENT OF DREAMCATCHER BUILDING DESIGNS.

SAMPLE BARN PLAN


Dreamcatcher Building Designs (941) 462-0110 www.dreamcatcherbuildingdesigns.com

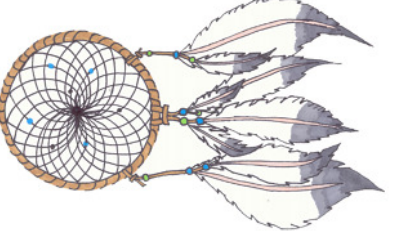

ROOF FRAMING PLAN SCALE: 3/16" = 1'-0"


PROVIDE 2 X 4 BLOCKING BETWEEN BOTTOM CHORDS OF TRUSSES @ 12" O.C. WITH SIMPSON A34 @ TRUSS BOTTOM CHORD AND (3) 10D NAILS @ STUD, TYPICAL FIRST BAY

ROOF NOTES:
PRE-ENGINEERED WOOD TRUSSES @ 24" O.C.
PITCH: 5/12
OVERHANGS: 24" TYPICAL (NORMAL & GABLE)
ALL TRUSSES ARE TO BE ATTIC TRUSSES.

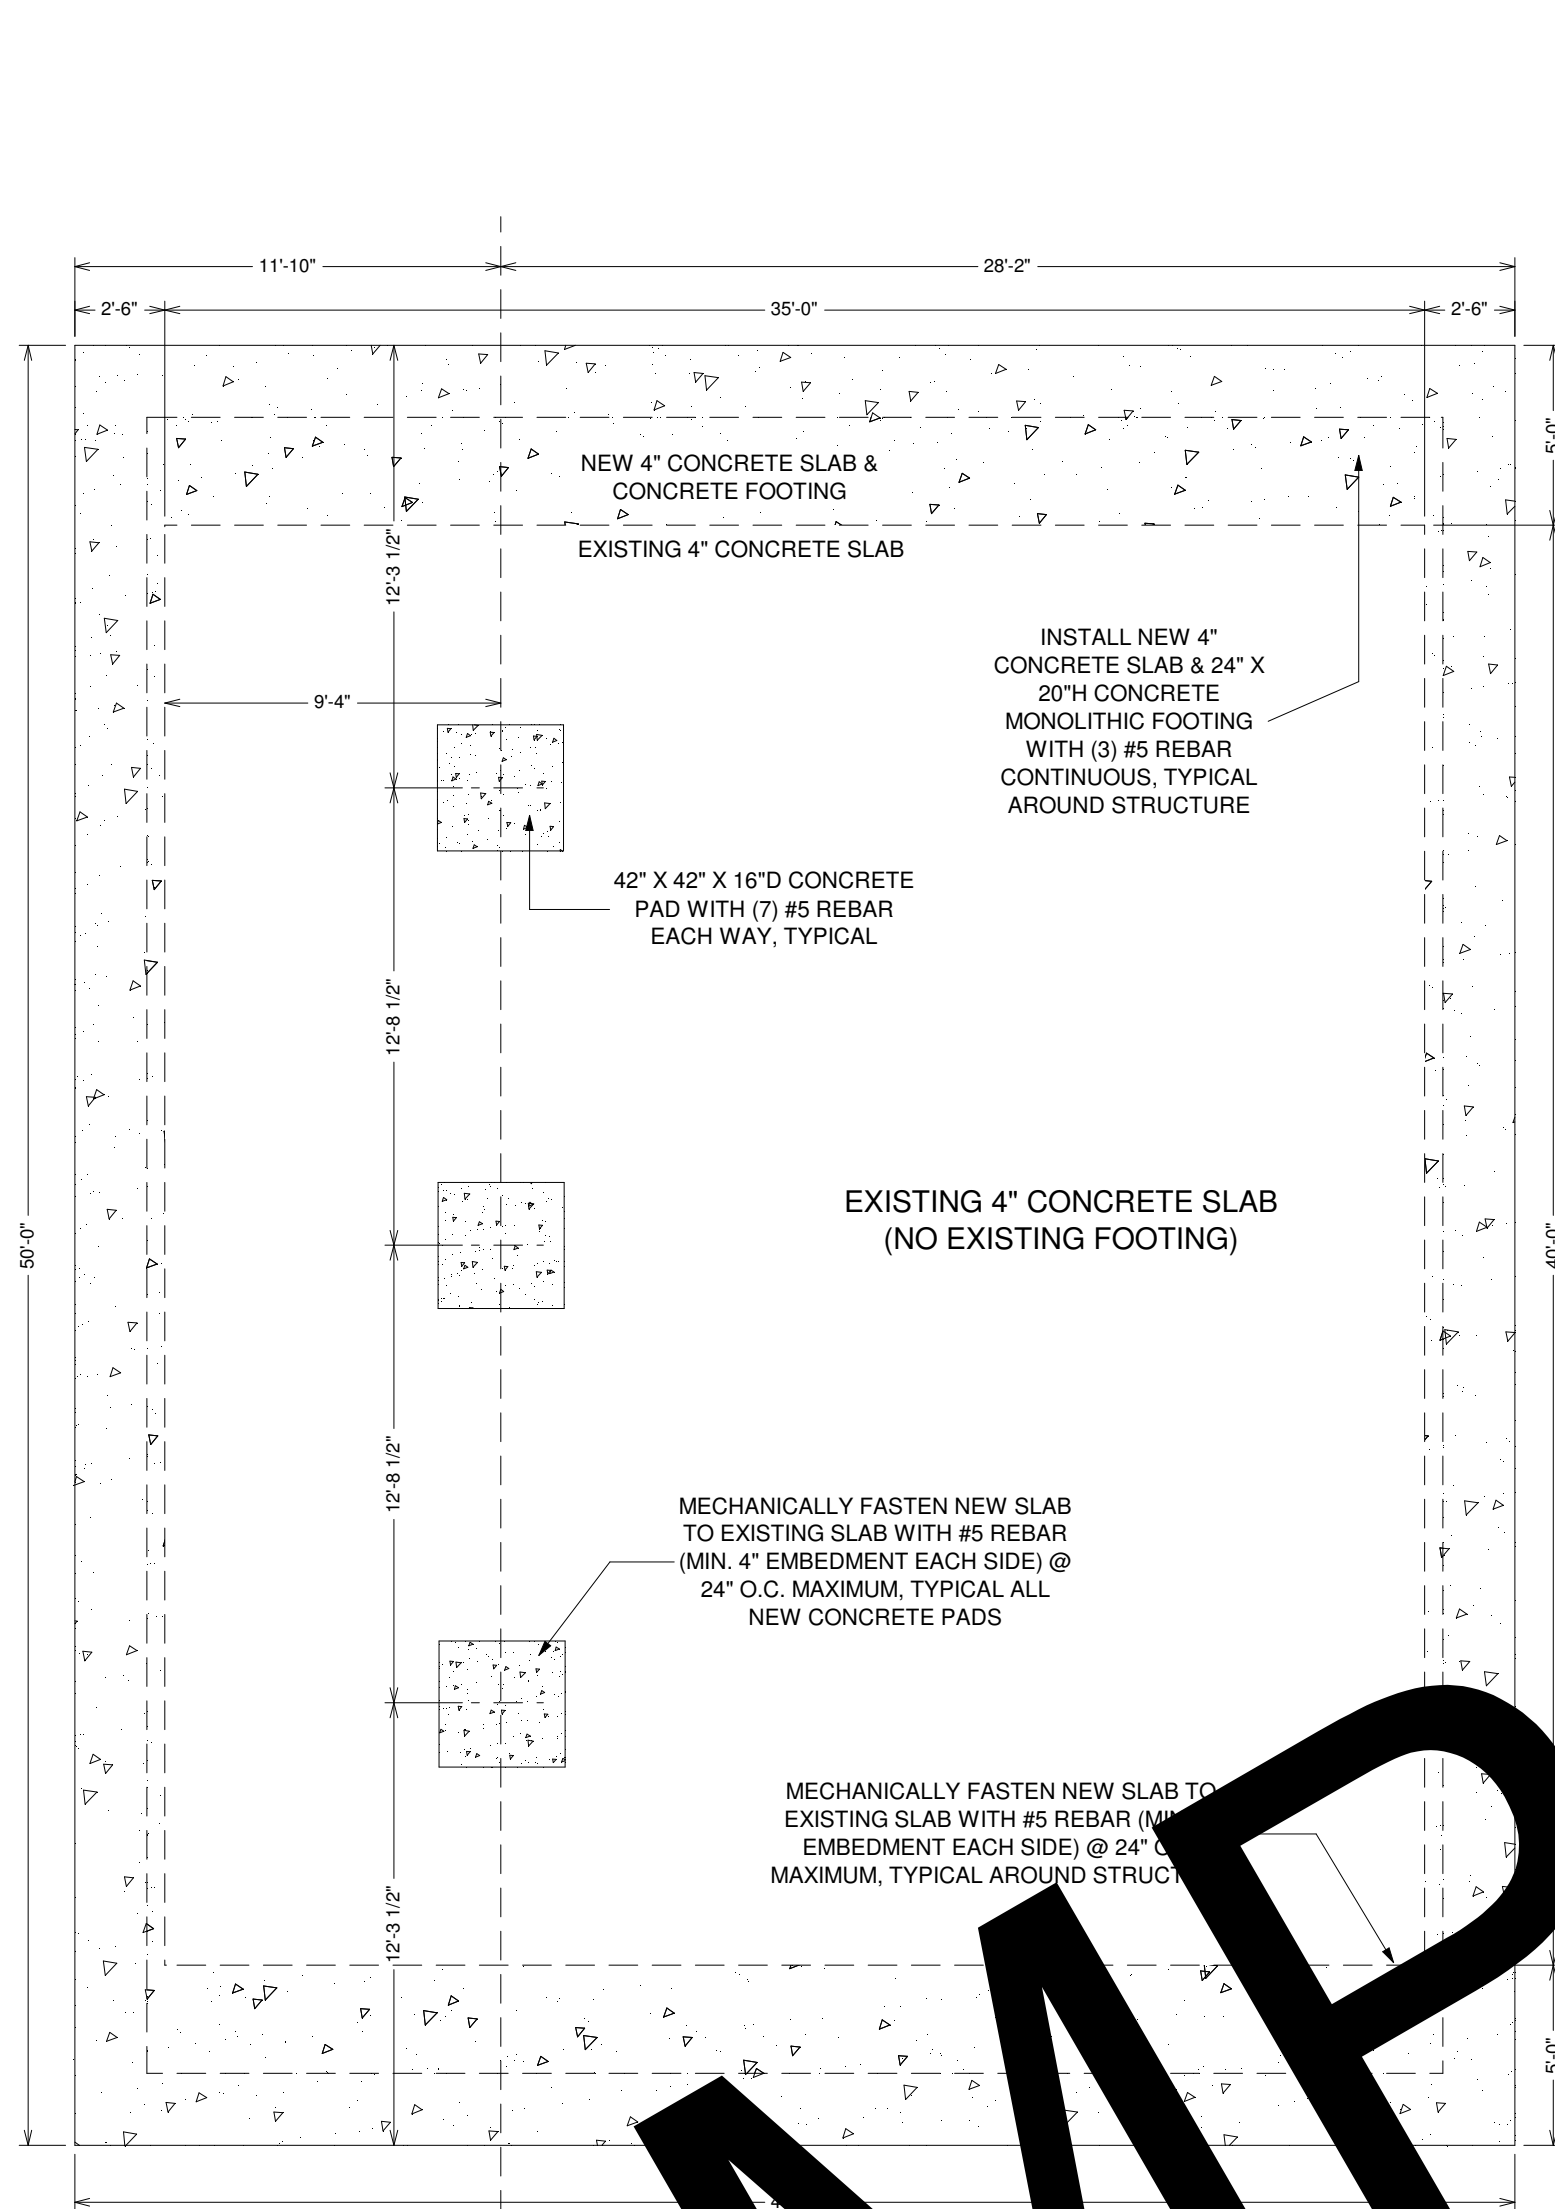


FOUNDATION PLAN SCALE: 1/8" = 1'-0"

SAMPLE

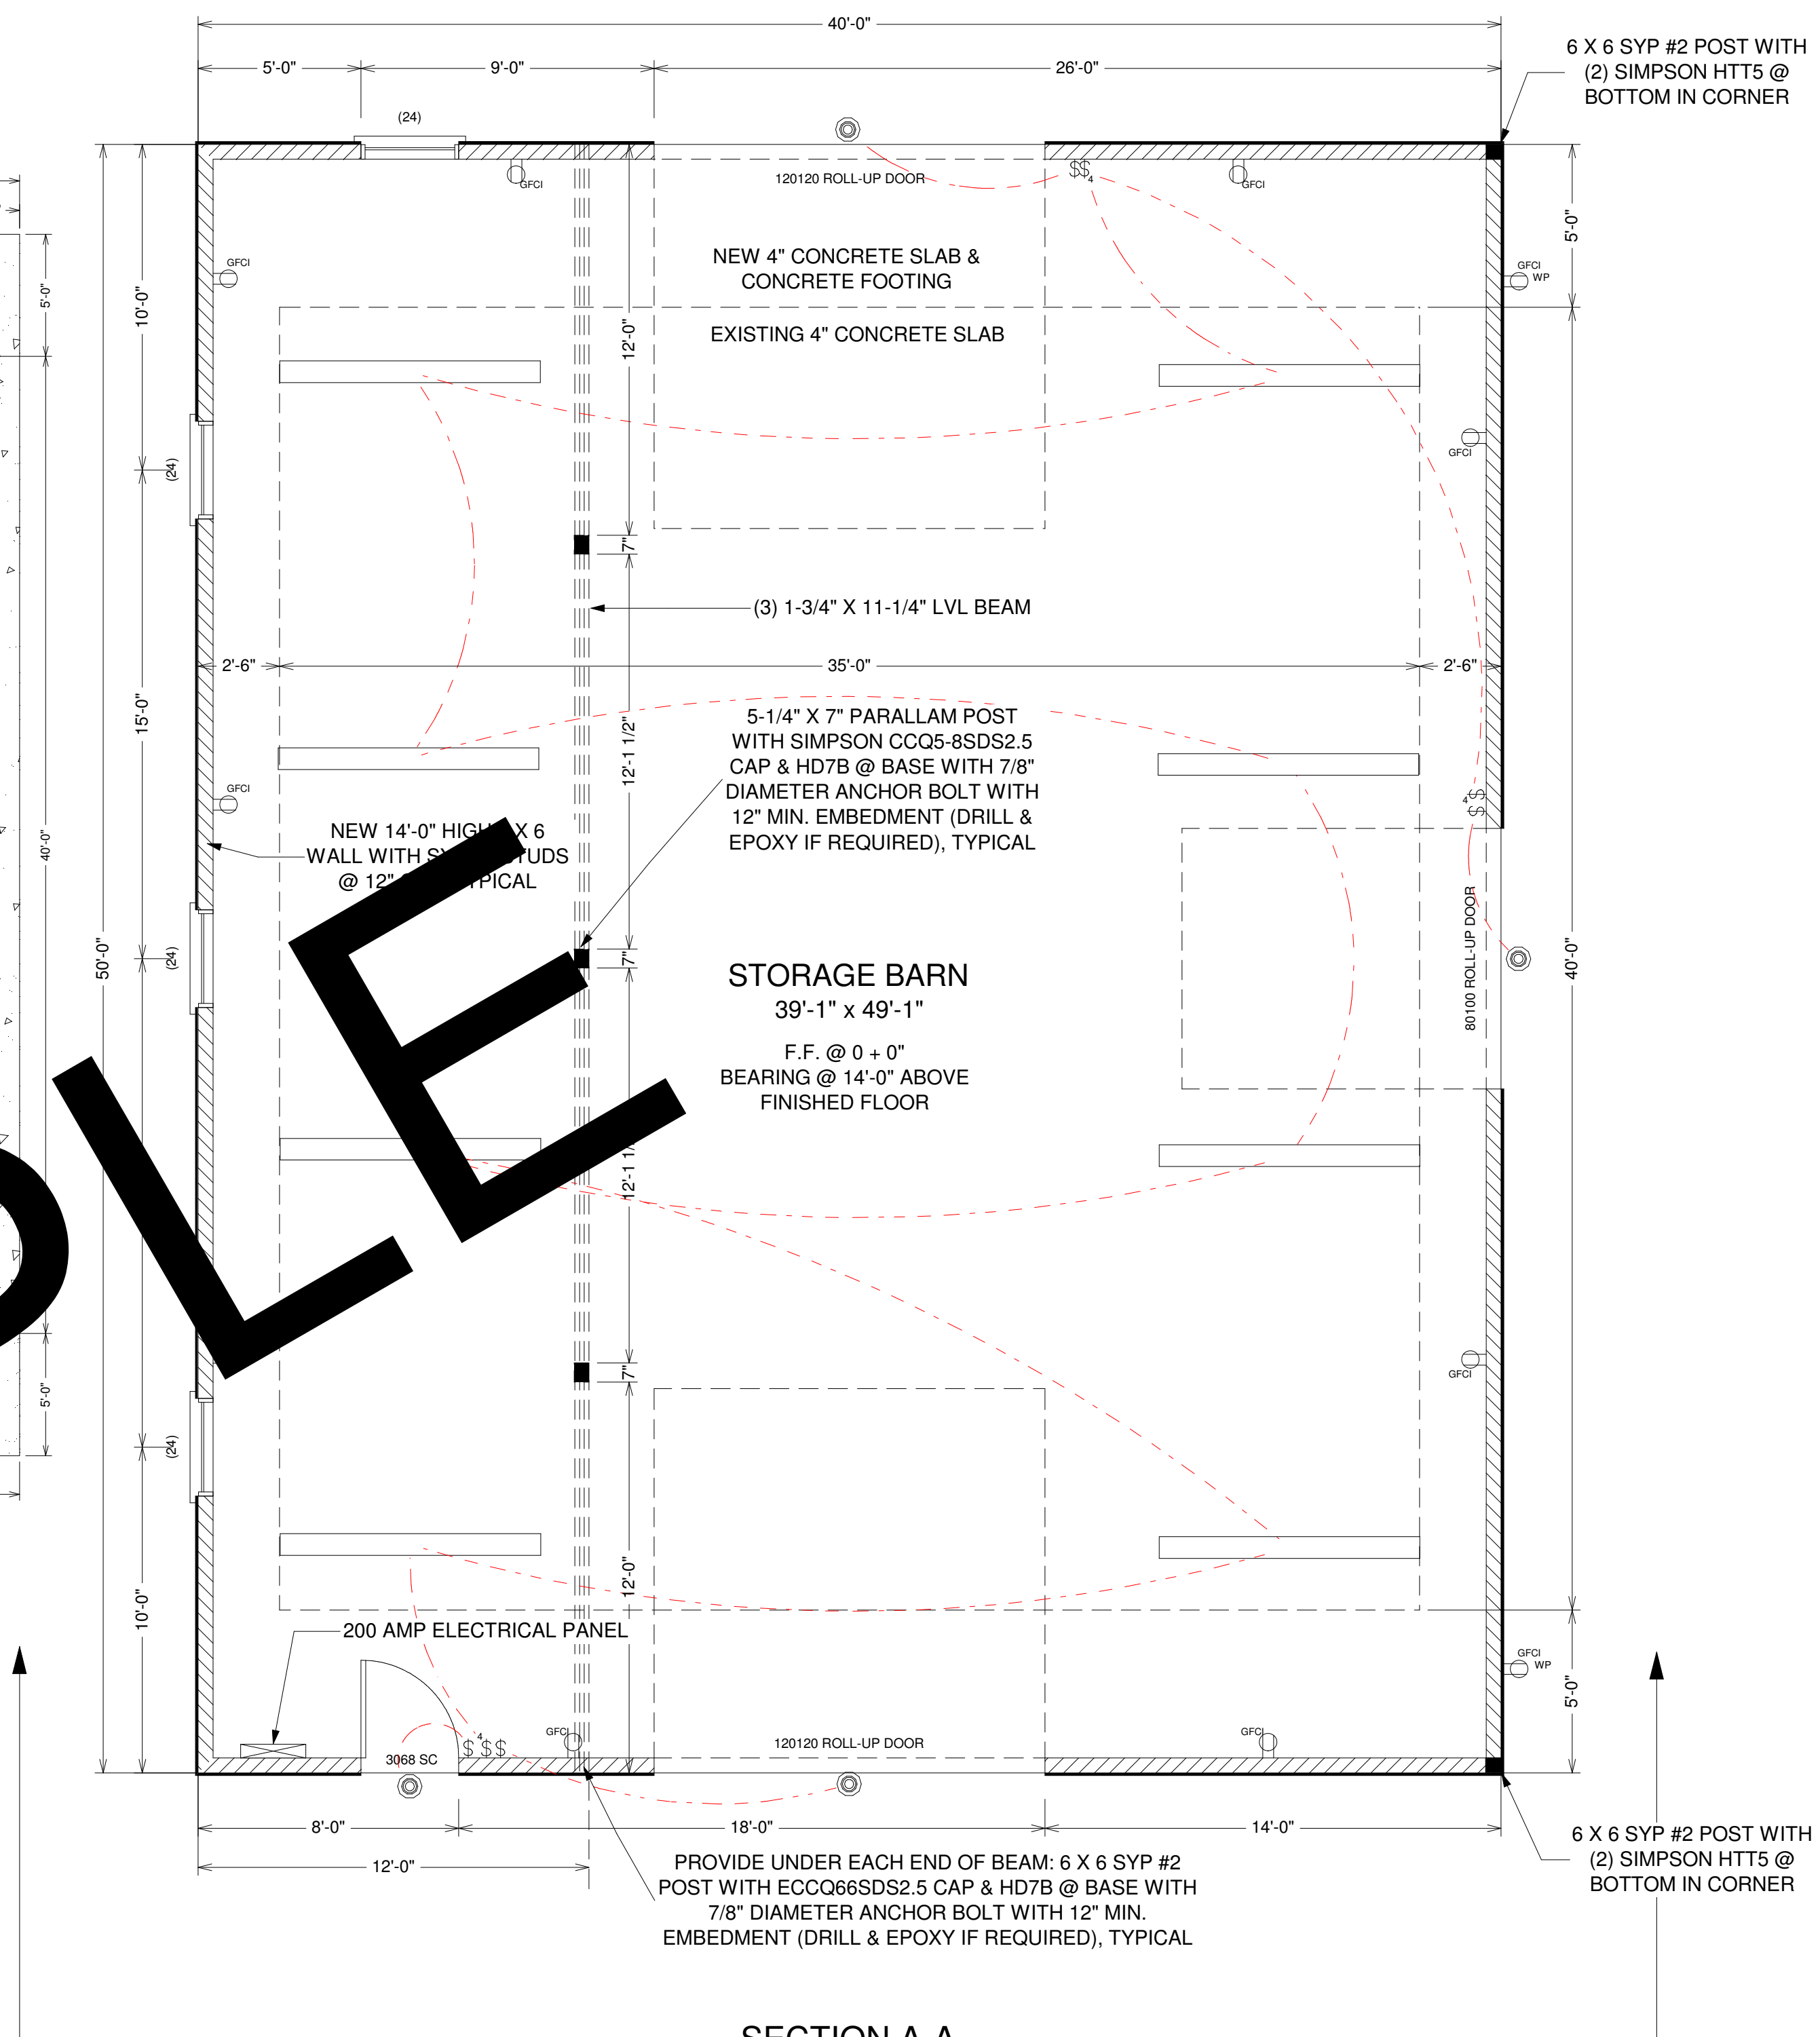

SECTION A-A
FLOOR & ELECTRICAL PLAN SCALE: 1/4" = 1'-0"

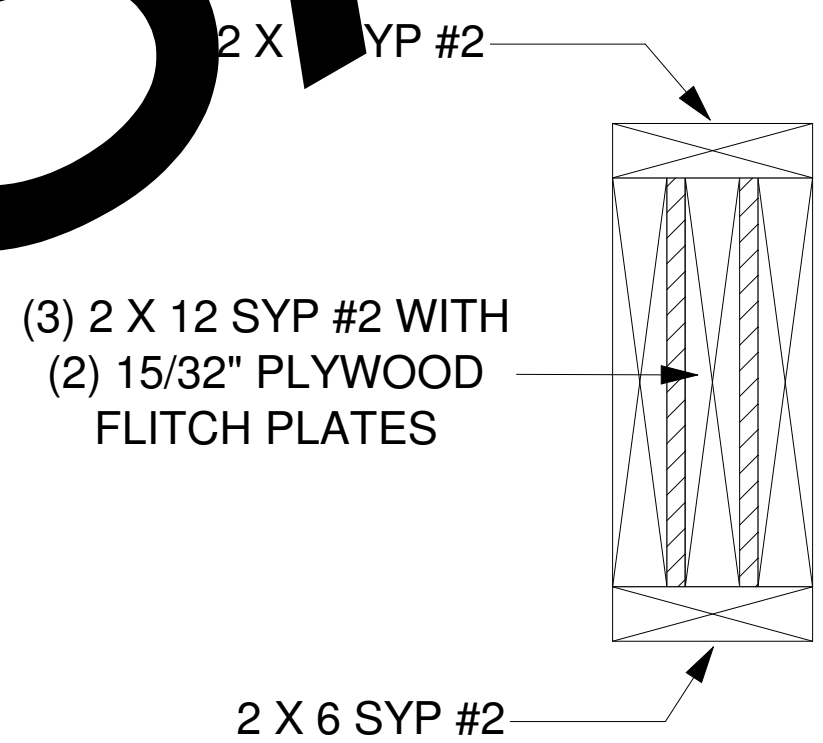

TYPICAL HEADER DETAIL NOT TO SCALE




THIS PROJECT IS DESIGNED IN ACCORDANCE WITH THE 2014 FLORIDA BUILDING CODE, 5TH EDITION.

EXPOSURE: C
DESIGN WIND SPEED: 140 MPH, 3-SECOND GUST
RISK CATEGORY: I


THIS DESIGN IS THE INTELLECTUAL PROPERTY OF DREAMCATCHER BUILDING DESIGNS. IT IS NOT TO BE REPRODUCED OR REUSED WITHOUT THE EXPRESS CONSENT OF DREAMCATCHER BUILDING DESIGNS.

SAMPLE BARN PLAN


Dreamcatcher Building Designs (941) 462-0110 www.dreamcatcherbuildingdesigns.com

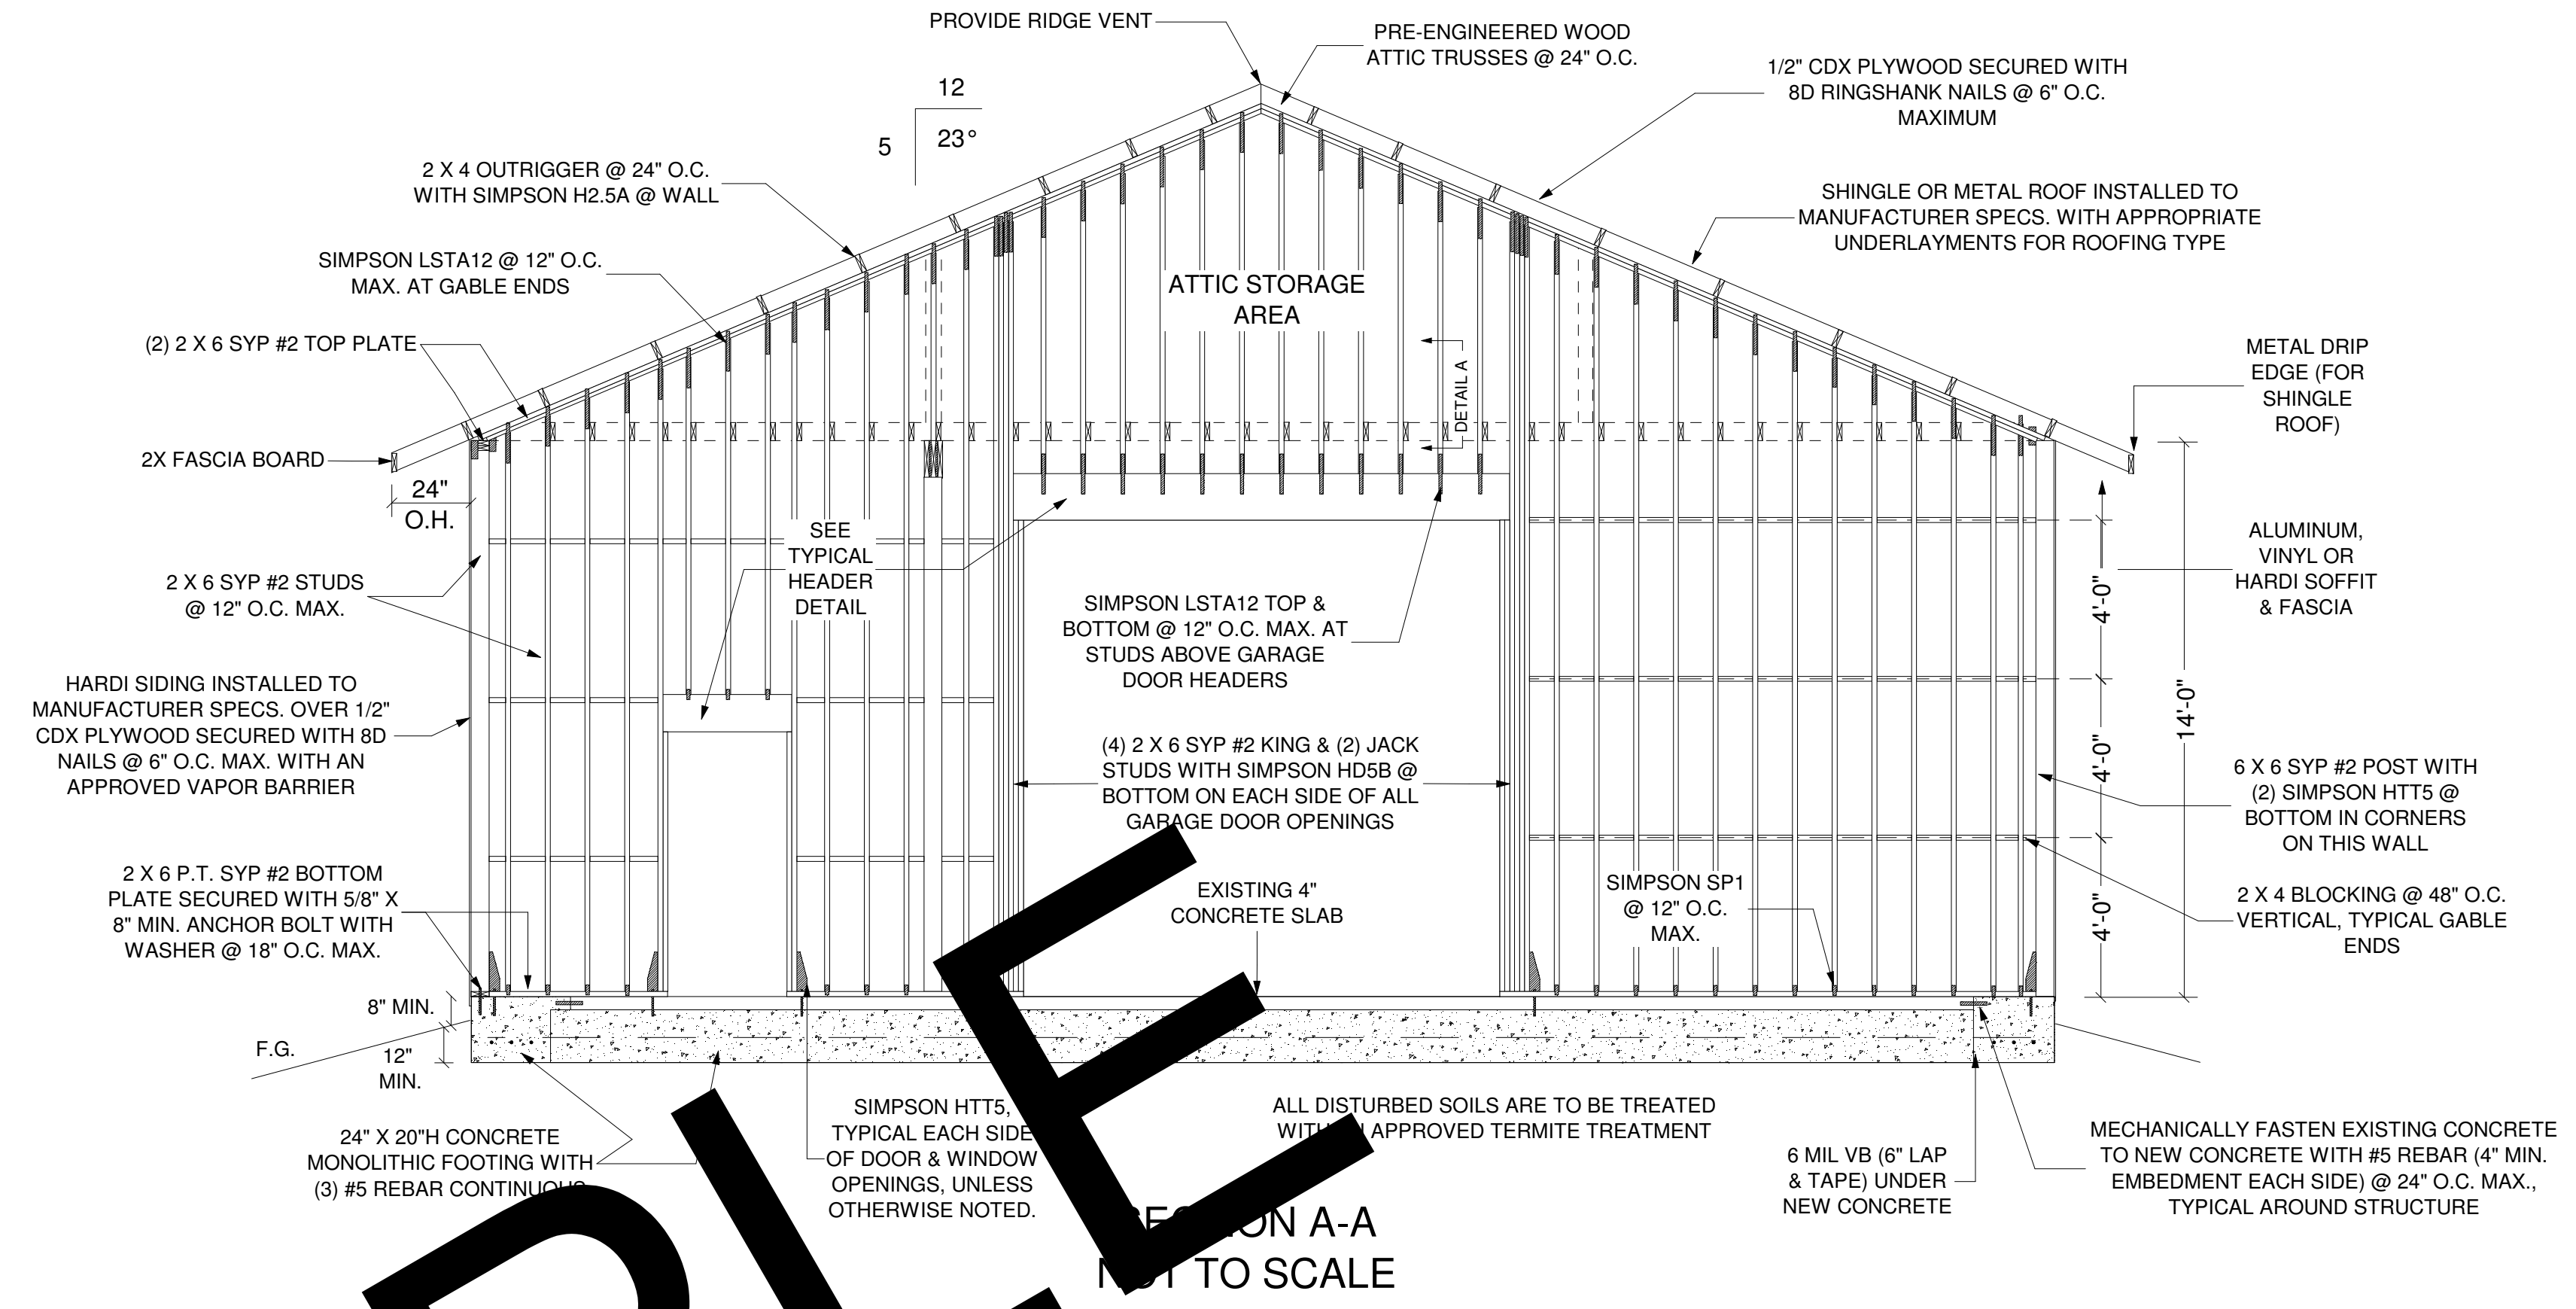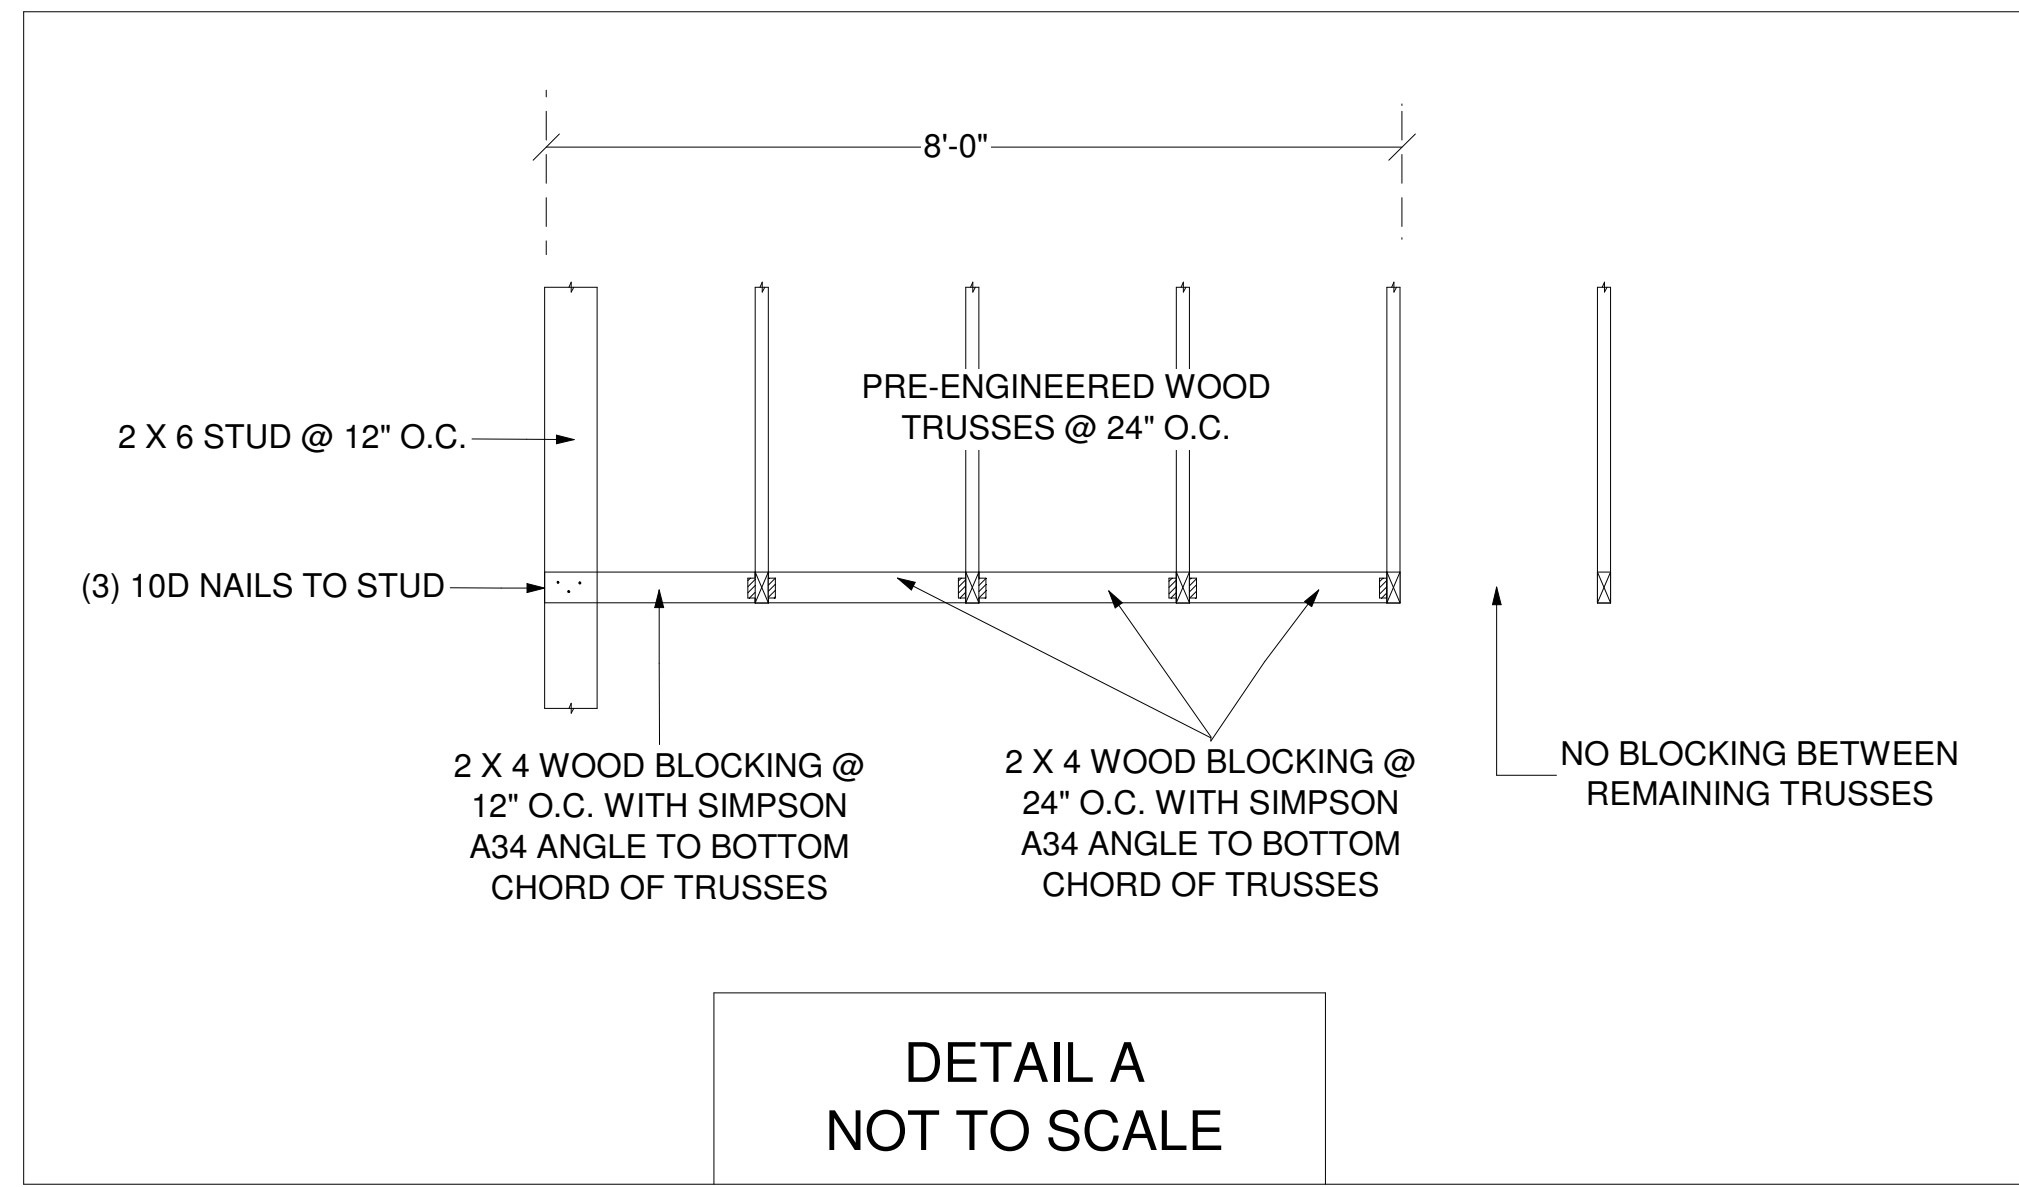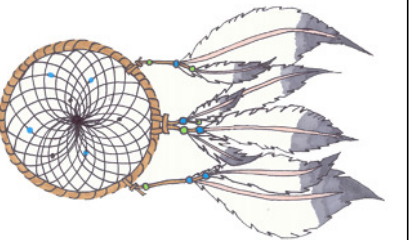


FRONT ELEVATION
SCALE: 3/16"

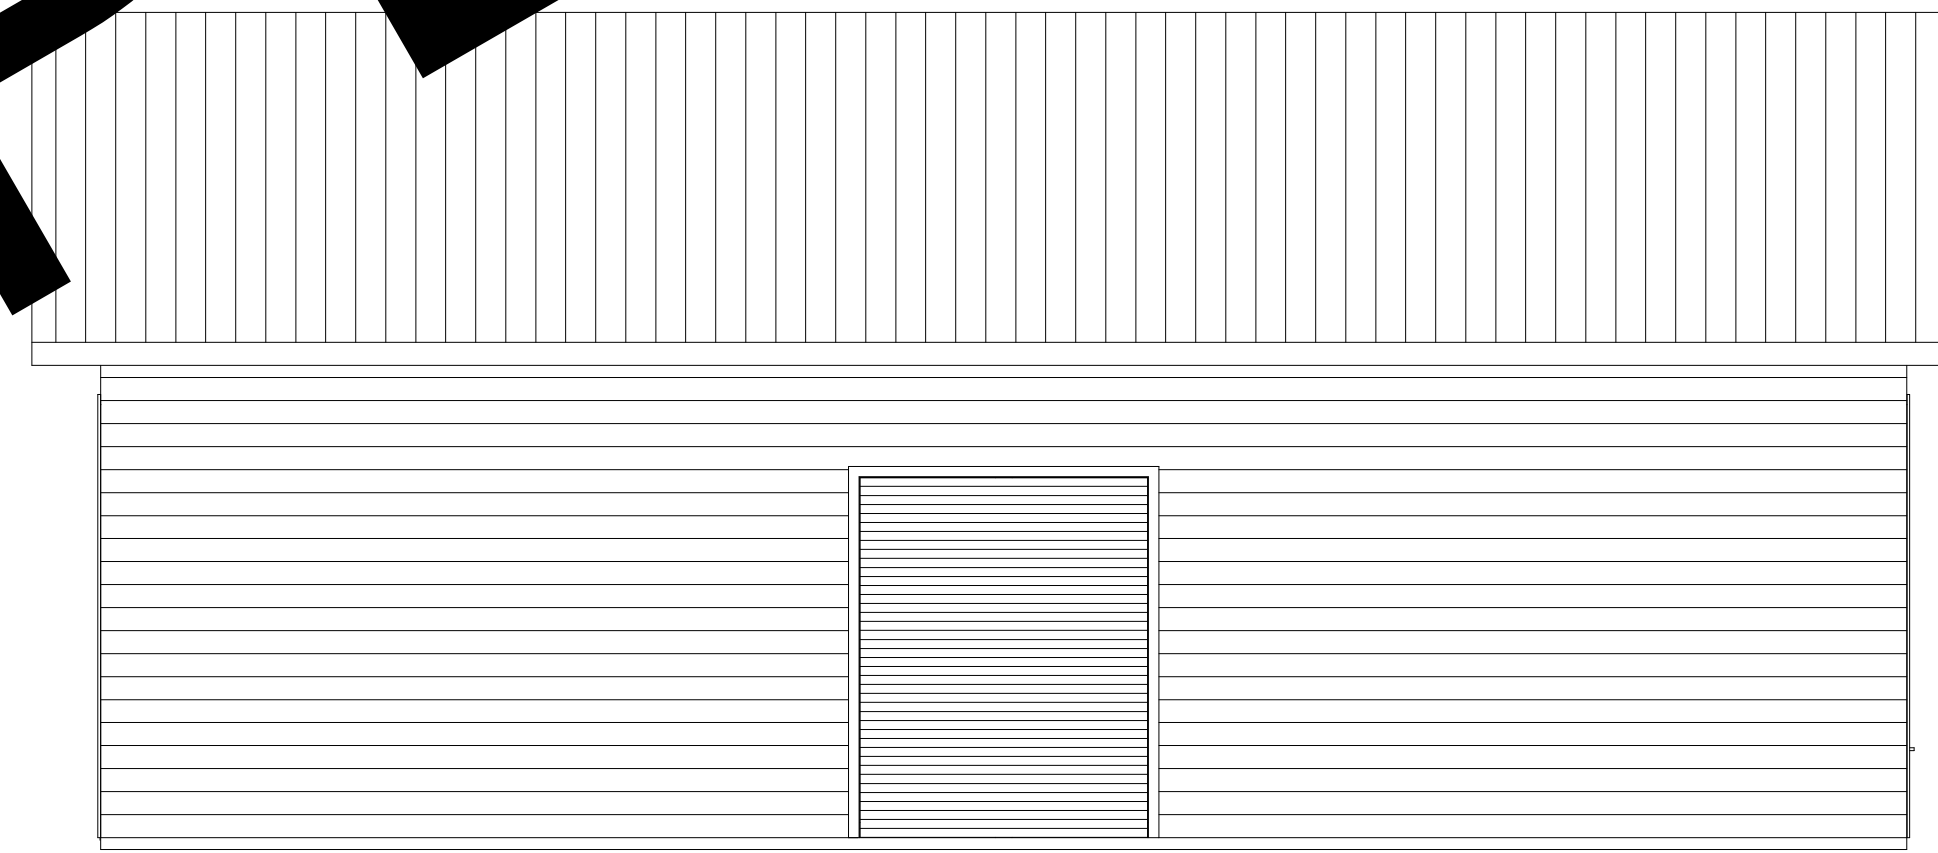

RIGHT ELEVATION
SCALE: 3/16" = 1'-0"

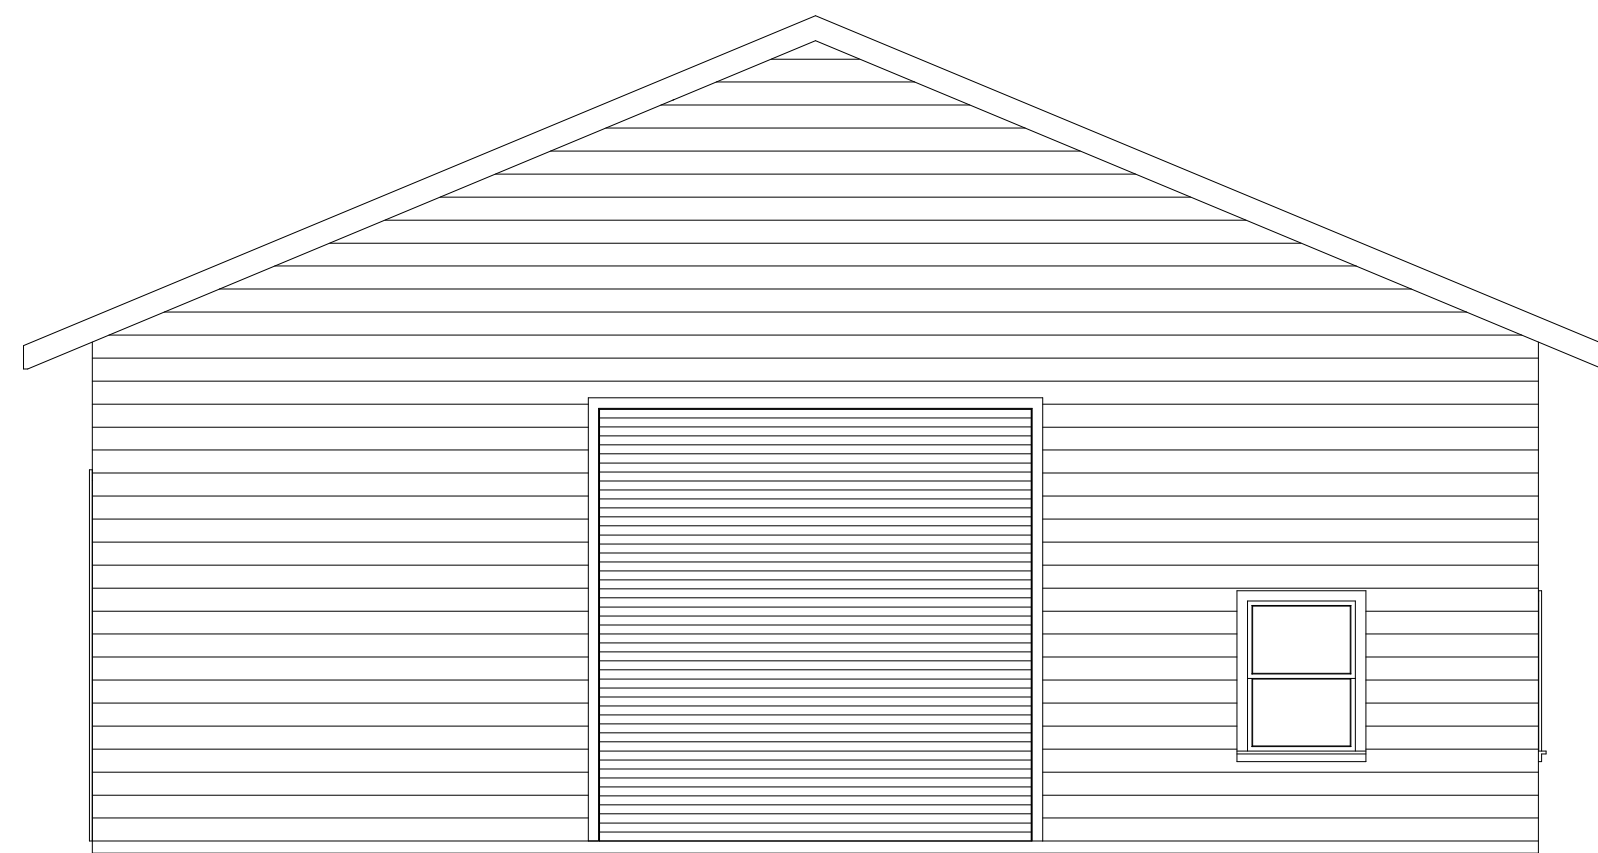

REAR ELEVATION
SCALE: 3/16" = 1'-0"

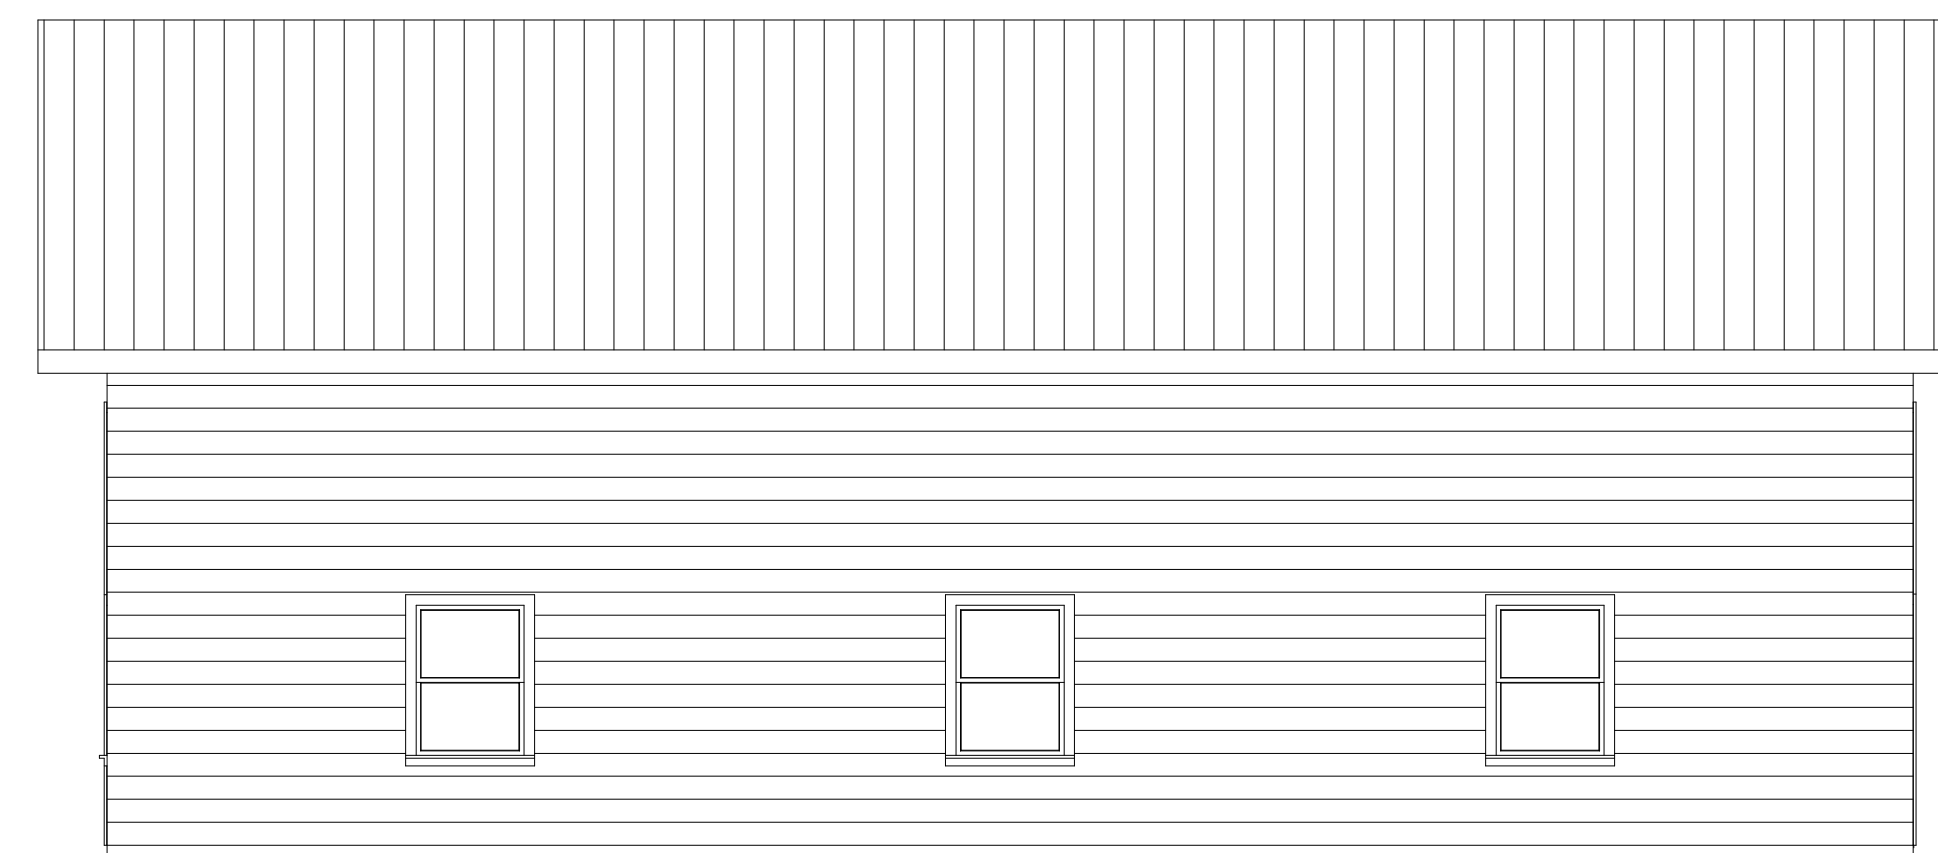

LEFT ELEVATION
SCALE: 3/16" = 1'-0"

SAMPLE